


FIRST FLOOR PLAN

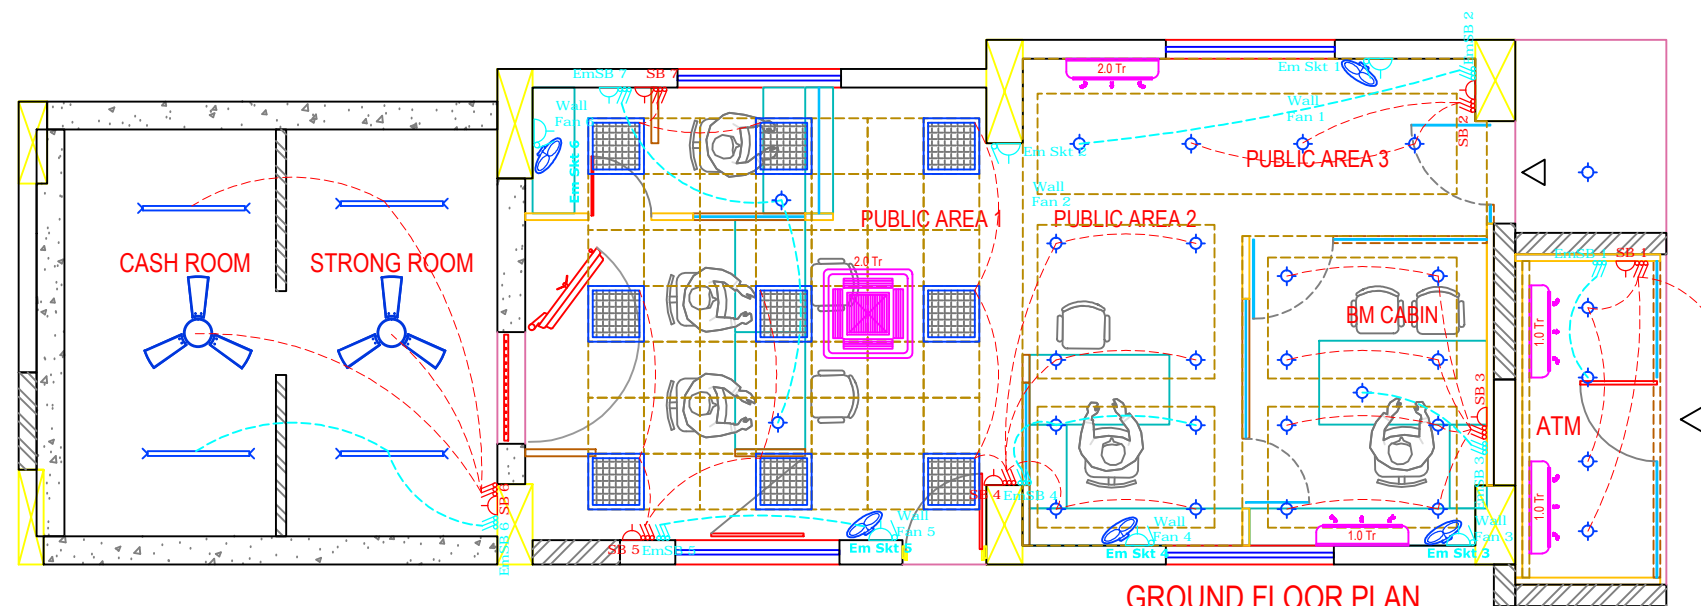

GROUND FLOOR PLAN

Legend :	
	Switch Board without Socket
	Switch Board without Socket
	Switch Board with Socket on Board
	Down Lighter Fixture
	Down Light Fixture Emergency
	DP / FP MCB in Metal Enclosure
	Distribution Boards
	600 x 600 size Luminaire
	Exhaust fan
	Fluorescent Light Fixture
	Ceiling Fan
	Wall Fan
	16A SOCKET WITH SWITCH
	Light Point Wiring
	Emm Light Point Wiring

Architect :
 NARENDRA SARDESHPANDE & ASSOCIATES
 43, Shreekul, Flat no 2, Ground Floor,
 United Western Housing Society,
 Near Tathwade Garden, Karvenagar, Pune - 411052
 Contact : 9822072016, (020)25454297

Client : **CANARA BANK**

Scale : Drawn :

Date : 01-02-2024 Chkd :

Project : **CANARA BANK, BAVDHAN BRANCH , PUNE**

Title : **LIGHT POINT WIRING LAYOUT**

Drg No.: Rev. : 03