

	18W LED DOWN LIGHT
	2X2 FITTINGS
	WALL FAN
	LED SINGLE TUBE
	EXHAUST FAN
	CEILING FAN
	ANGLE HOLDER WITH BULB
	LED STRIP LIGHT
	WALL FAN
	CABIN FAN

ENARC CONSULTANTS
ARCHITECTS AND ENGINEERS
 M. G. Road, Thrissur - 1.
 Tel. : +91 (487) 2441901
 E-mail : office@enarc.net.in


PROPOSED INTERIOR FURNISHING
FOR CANARA BANK,
KARUNAGAPPALLY BRANCH
ELECTRICAL LAYOUT

	CUPBOARD 75 CM HEIGHT
	CUPBOARD 120 CM HEIGHT
	CUPBOARD 210 CM HEIGHT
	FULL GLAZED PARTITIONS
	DOUBLE SKIN SOLID GLAZED PARTITIONS
	SOLID PARTITIONS
	SEMI PARTITIONS (210 cm ht. Half glazed)
	SEMI PARTITIONS (120 cm ht. Half glazed)
	FIRE RATED CEMENT PARTITION
	COMPOSITE PANEL + CEMENT PARTITION

Drawn By Ar.PARVATHY RAJAN
 Chief Architect
 Architect Ar.PRAVEEN.P
 B. Arch.[Reg], A.I.I.A, A.I.I.I.D

Chief Architect
 Ar. K. RAMAKRISHNAN
 B.Sc.(Engg), F.I.E, C. Eng (I),
 F.I.V, I.I.I.D, F.I.I.A. (Regd)

Date: 06-03-2023	Sheet No : 03
Revision Date: 07-03-2023 08-03-2023 09-03-2023 13-03-2023 16-03-2023 21-03-2023	Drawing No: Scale: Not to scale All Dimensions are in CMs.

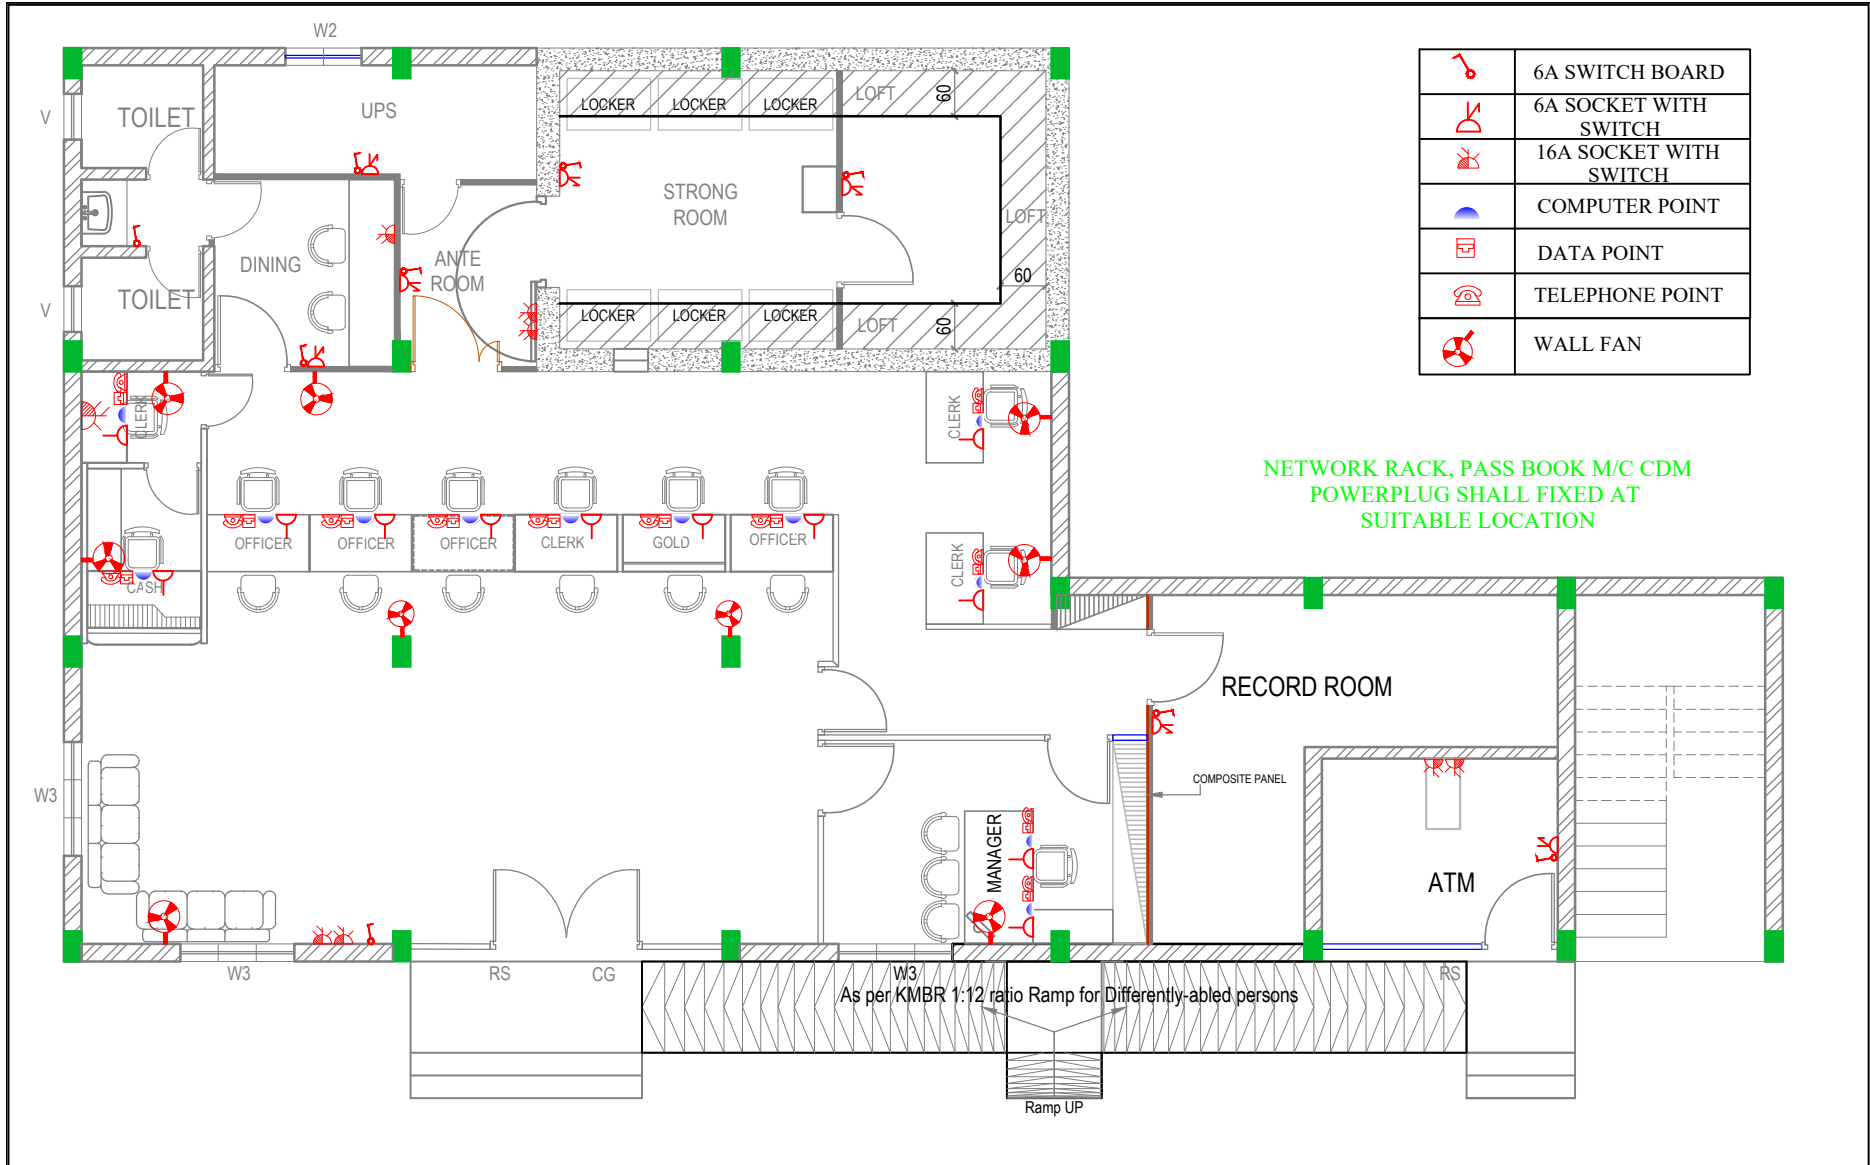

	6A SWITCH BOARD
	6A SOCKET WITH SWITCH
	16A SOCKET WITH SWITCH
	COMPUTER POINT
	DATA POINT
	TELEPHONE POINT
	WALL FAN

ENARC CONSULTANTS
ARCHITECTS AND ENGINEERS
M. G. Road, Thrissur - 1.
Tel. : +91 (487) 2441901
E-mail : office@enarc.net.in

**PROPOSED INTERIOR FURNISHING
FOR CANARA BANK,
KARUNAGAPPALLY BRANCH**

POWER LAYOUT

LEGEND

	CUPBOARD 75 CM HEIGHT
	CUPBOARD 120 CM HEIGHT
	CUPBOARD 210 CM HEIGHT
	FULL GLAZED PARTITIONS
	DOUBLE SKIN SOLID GLAZED PARTITIONS
	SOLID PARTITIONS
	SEMI PARTITIONS (210 cm ht.Half glazed)
	SEMI PARTITIONS (120 cm ht.Half glazed)
	FIRE RATED CEMENT PARTITION
	COMPOSITE PANEL + CEMENT PARTITION

Drawn By	Ar.PARVATHY RAJAN
Chief Architect	Ar. K. RAMAKRISHNAN B.Sc.(Engg), F.I.E., C. Eng (I), F.I.V.,I.I.I.D.,F.I.I.A. (Regd)
Architect	Ar.PRAVEEN.P B. Arch.[Reg], A.I.I.A, A.I.I.I.D

Date: 06-03-2023	Sheet No : 01
Revision Date:	Drawing No:
07-03-2023	Scale: Not to scale
08-03-2023	All Dimensions are in CMs.
09-03-2023	
13-03-2023	
16-03-2023	
21-03-2023	
22-03-2023	