


LEGEND			
S.No.	SYMBOL	DESCRIPTION	Nos.
1	⊕	DOWN LIGHTER	22
2	—	T-5	13
3		600X600 DOWN LIGHT	17
4	---	T-5	03

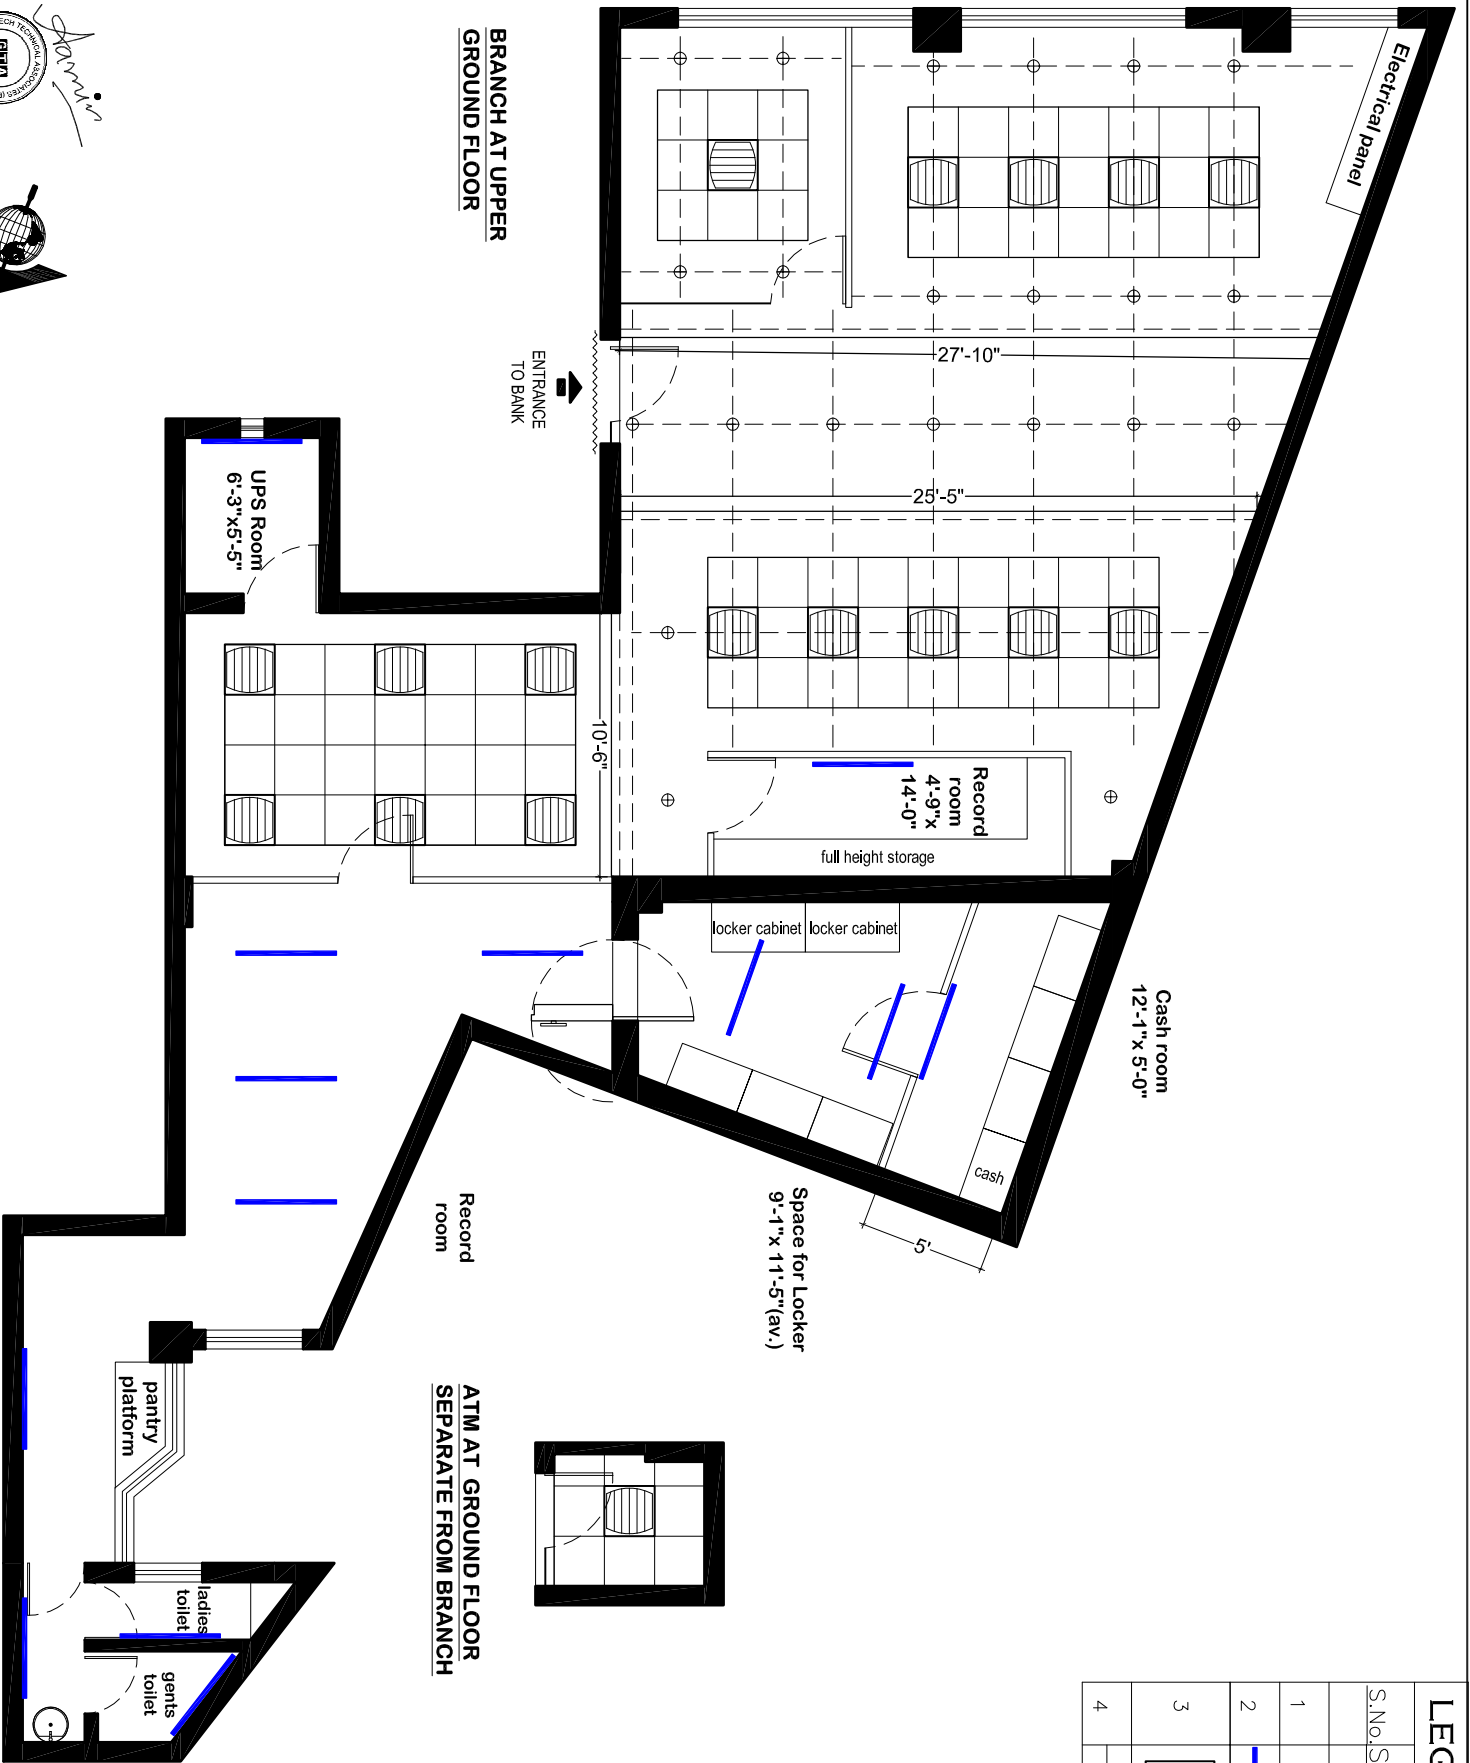

- Notes**
- All dimensions are to be read and not to be scaled.
 - Contractor must verify all dimensions as per site before commencement of any work.
 - Contractor must notify Architect and/or Project Manager of all discrepancies in the drawing & clarify with them.
 - All door and window openings are to be verified as per schedule.
 - All services to be co-ordinated with structures.
 - Contractor must take approval of layout from Architect before start of construction.
- Architects:**
- Geotech Technical Associates (P) LTD.**
- B-004, Amrapali Pincney Estate,
Sector - 76, Noida - 201301
ph.: 9818938150, 9910297218
e-mail: technicalassociates@gmail.com

Client:

CANARA BANK
SUKRALI BRANCH,
GURURAM

Lighting Plan

Job No. _____ Drawing No. _____
 Down Checked CN/LU/AP/02
 A.I.V. 30/08/2024
 Date 18/08/24 Scale 1/80 ON A3

Job No.	Drawing No.
Down	Checked
A.I.V.	30/08/2024
Date	18/08/24
Scale	1/80 ON A3
Revisions	