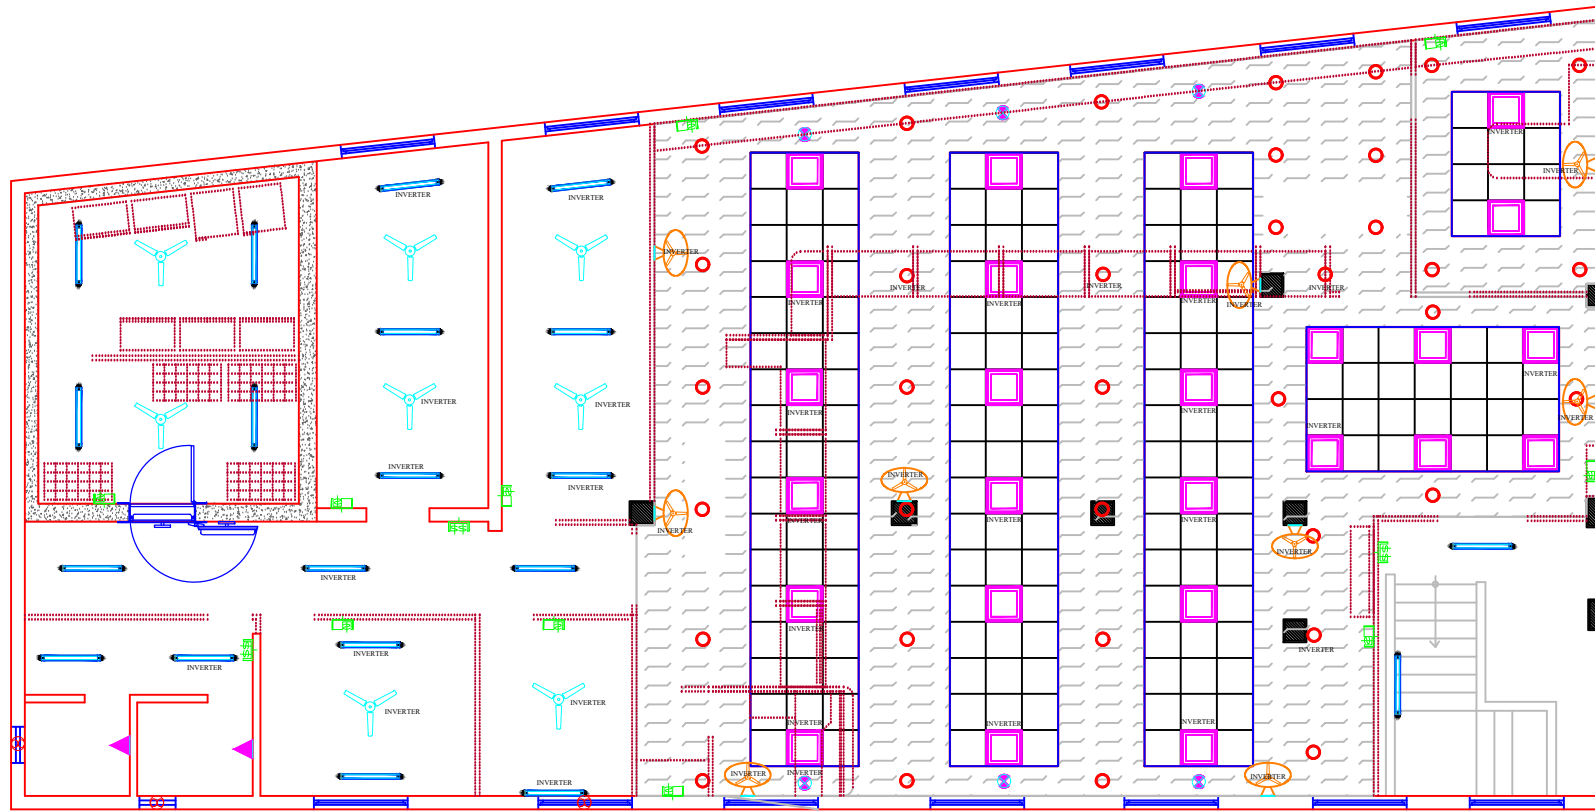


	1x18W LED TUBE		9W LED GLASS BULB WITH BATTERY HOLDER		300MM SWEEP EXHAUST FAN (65W)		COMBINED (6A SOCKET) SWITCH BOARD
	36 W SQUARE LED DOWN LIGHTER		1200/1050MM SWEEP 5 STAR RATED CEILING FAN (65W)		150MM SWEEP EXHAUST FAN (40W)		INDEPENDENT SWITCH BOARD
	12 W CIRCULAR LED DOWN LIGHTER		400MM SWEEP WIDE SPEED CONTROL WALL FAN (40W)		4.8W/M LED STRIP LIGHT (Blue)		9W CIRCULAR LED DOWN LIGHTER
					ASTRO SPOT LIGHT (3W)		

NOTE : All dimensions are in inches & feet

Job No. : CB/TRVP/KL

Drg No. : 01 - LL/23

Date : 12.07.2023

Rew Date :

Drawn By : Balaji


CKD By : Vinitha Mukund

LIGHTING LAYOUT PLAN

FIRST FLOOR

CANARA BANK

THIRUVEGAPPURA BRANCH

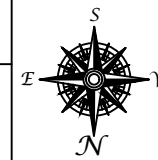

H3 - Ras Subiksha Mascot,
Behind Deepam Hospital,
Trichy Road,
Ramanathapuram,
Coimbatore - 641 045.
0422 - 2313958.

Email: architect.shrishti@gmail.com

