


CIVIL LAYOUT

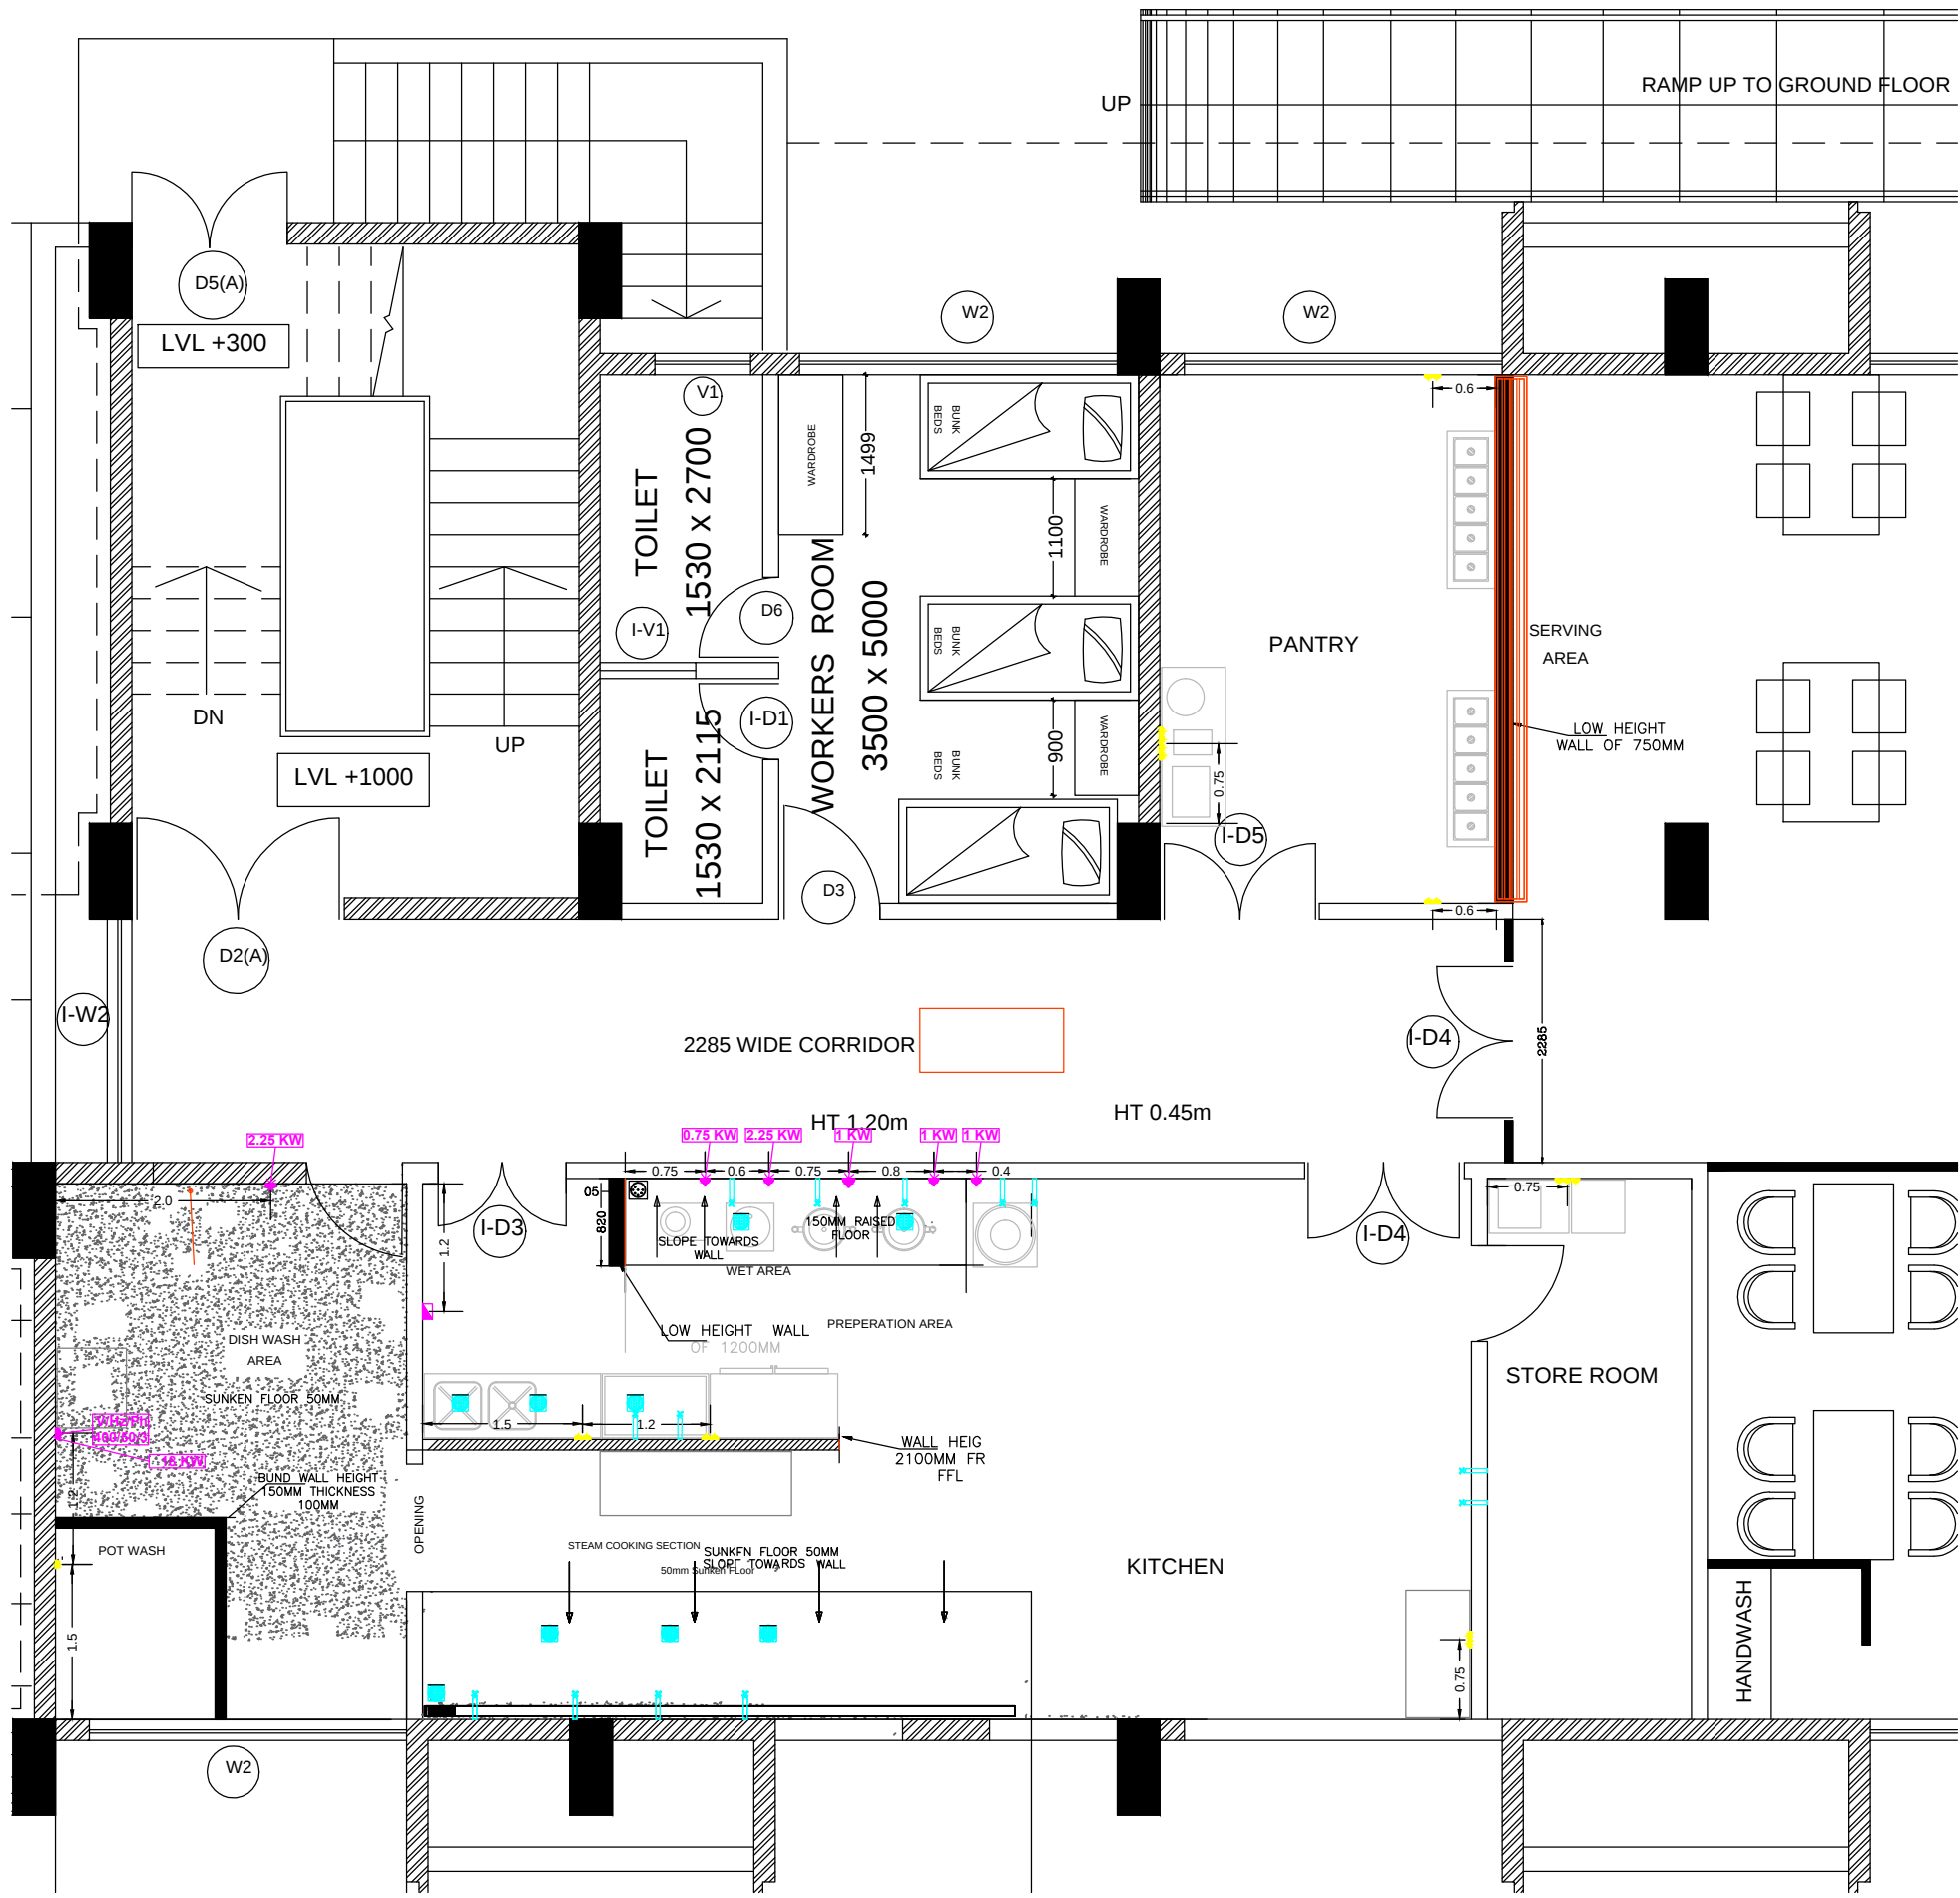

LEGEND

- Single Phase $\frac{5}{15}$ Amp. Plug Point @ 1500 from FFL
- Three Phase Industrial Socket @ 1500 from FFL
- * Δ Three Phase Starter @ 1500 frn FFL

ELECTRICAL CONNECTIONS

Proposed Kitchen facility at Currency Chest,
Canara Bank, Bagalur, Bengaluru.

Drawing No: CB/04/23-24
Sheet No : 05
Date : 12/03/2024
Revision No :R0
Rev Date :



	Name
Drawn By	Naveen
Checked By	Ar.Anjali Udoshi

NAVEEN ENTERPRISES
AR. ANJALI N. UDOSHI
Architect, Interior and Landscape Designer,
#112,Laxmi layout,Gokul Road, Hubli.
Hello : M- 9448061435,
email: enterprisesnaveen2005@gmail.com




NO.	PARTICULARS	QTY
STORES (GRAIN, DRY, WET & COLD):		
1	WORK TABLE WITH 1 U/S & 1 DRAWER, 1150X600X850+100MM ht.	1
2	TABLE TOP WEIGHING SCALE, 0-10 KG.	1
3	P LATF ORM WEIGH NG SCALE, 0-200 KG.	1
4	OIL / TIN 3 SH ELVES RACK, 600X500X1200+50mm ht.	1
5	DUN NAGE RACK, 1650X550X250mm ht.	2
6	S. S. 3 SHELVES STORAGE RACK, 1100X500X1800mm ht.	3
7	STORAGE BINS ON CASTORS, 450X450X650mm ht.	6
8	S. S. 5 SHELVES STORAGE RACK, 800X400X 1800mm ht.	1
9	WORK / CUTTING TAB LE WITH SINK & 1 U/S, 1350X600X850+100mm ht.	1
10	VEGETAB LE STORAGE RACK WITH 10 X 15 LIT. PLASTIC BINS, 450X700X1650mm ht.	1
11	ONION / POTATO BINS ON CASTOR, 600X600X700mm ht.	2
12	CHEST FREEZER,900X600X850mm ht.	1
13	VERTICAL FOU R DOOR REFRIGERATOR, 1200X600X2000mm ht.	1
14	WORK / CUTTING TAB LE WITH 2 U/S, 1350X600X850+100mm ht.	1
PRE-PREPARATION AREA:		
15	P LANETARY DOUGH MIXER, 25Kg Capacity	1
16	TILTING WET MASALA GRINDER, 10 LIT.	2
17	P ULVERISER, 3 HP	1
18	POTATO PEELER, 20 KG	1
HOT KITCHEN (BULK COOKING/BURNER/CHAPATY/PANTRY):		
19	STEAM GENERATOR (SUITAB LE FOR 20,21,22) WITH STEAM PIPELIN E	1
20	STEAM COOKING PAN, 60 LIT. CAPACITY.	3
21	MILK WARMING PAN, 50 LIT. CAPACITY.	1
22	IDLY STEAMER, 2 X 100	1
23	SIDE TABLE WITH 1 U/S, 450X600X750+100mm ht.	6
24	TWO BURNER COOK ING RANGE, 1200X600X650+200mm ht.	3
25	SINGLE SINK UNIT, 600X650X850+100mm ht.	2
26	CHAPATY PLATE WITH PUFFER, 1350X600X850+100mm ht.	2
27	BULK FRYER, 600X600X650mm ht. (20 LH Capacity)	1
28	DEEP FAT FRYER, 10 LIT	1
29	PANTRY TABLE WITH 2 U/S, 1500X600X850+100mm ht.	1
30	DOSA PLATE, 1200X600X850+100mm ht.	1
31	SANDWICH GRILLER	1
32	MIXER / JUICER	1
33	CITRUS /CARROT JUICER	1
34	WORK TABLE WITH SIN K & 1 U/S, 1500X600X850+100mm ht.	1
35	TWO BURNER TEA / COFFEE RANGE, 1200X600X650+200mm ht.	1
SERVICE COUNTERS:		
36	P LATE STACK ING TABLE WITH TRAY RAIL & 1 U/S, 1300+300X500X850mm ht.	2
37	SERVICE COUNTER WITH 5 X 8 LIT. (1/2X200mm deep GN PANS WITH LID) HOT BAIN MARIE, 1 U/S, 3 SIDES CLOSED, TRAY RAIL & SNEEZE GUARD, 1500X450+300X850+450mm ht.	2
38	NEUTRAL SERVICE COUNTER WITH 2 U/S & 3 SIDES CLOSED, 900X450+300X850+450mm ht.	1
POT/PLATE/GLASS/TROLLEY WASH:		
39	SOILED PLATE LANDING COUNTER WITH TROUGH, 1 SINK & 1 CHUTE, 1650X600X850+100mm ht.	1
40	JET SPRAY	1
41	RACK LOADING TABLE WITH SINGLE SINK & RACK HOLDERS BELOW, 1500X650X850+100mm ht.	1
42	HOOD TYPE DISH WASHING MACHINE, 200-250 PLATES / HR CAPACITY.	1
43	RACK UNLOADING TAB LE WITH RACK HOLDERS BELOW, 1500X650X850+100	1
44	FOUR SHELVES CLEAN PLATE RACK, 1100X500X1800mm ht.	2
45	SIX SH ELVES CLEAN GLASS RACK, 750X400X1800mm ht.	1
46	THREE PIPE SHELVES UTENSIL DRAIN ING RACK, 1500X600X1400mm ht.	1
WATER STATION:		
47	WATER COOLER, 150 LIT.	2
48	GLASS / JUG TABLE WITH 1 U/S, 800X650X800+50mm ht.	2
GENERAL ITEMS & TROLLEYS:		
49	P LATF ORM TROLLEY, 900X700X 900mm ht.	1
50	TWO SHELVES MU LTI PU RPOSE TROLLEY, 750X600X900mm ht.	2
51	12 X 1LIT CONTAIN ER MASALA TROLLEY, 850X650X900mm ht.	1
52	WASTE BIN TROLLEY, 450mm dia. X 850mm ht.	4
53	3X3X1/1X200mm deep GN PAN TROLLEY,	1
54	CLEAN PLATE TROLLEY, 800X450X1400mm ht.	2
55	SOILED PLATE RECEIVIN G TROLLEY, 1000X500X1500mm ht.	2
56	FLOOR WASHING REEL HOSE	2
57	INSECT KILLERS, TWIN TUBE.	12
58	FIRE EXTINGU ISHERS,	4
59	AIR CURTAIN S, 900mm LONG.	3
60	AIR CURTAIN S, 1200mm LONG.	2
61	AIR CURTAIN S, 1500mm LONG.	3
62	LP GAS PIPELINE & FITTINGS, 8 X 2 CYLINDER SYSTEM.	1
63	LP GAS LEAKAGE DETECTION SYSTEM.	1
64	VENTILLATION & FRESH AIR SYSTEM.	1
65	VEGETABLE CUTTING MACHINE	1

Proposed Kitchen facility at Currency Chest,
Canara Bank, Bagalur, Bengaluru.

Drawing No: CB/04/23-24	
Sheet No : 01	
Date : 17/02/2024	
Revision No :R2	
Rev Date :22.03.2024	
N	
	Name
Drawn By	Naveen
Checked By	Ar.Anjali Udoshi

NAVEEN ENTERPRISES
AR. ANJALI N. UDOSHI
Architect, Interior and Landscape Designer.
#112,Laxmi layout,Gokul Road, Hubli.
Hello : M- 9448061435,
email: enterprisesnaveen2005@gmail.com

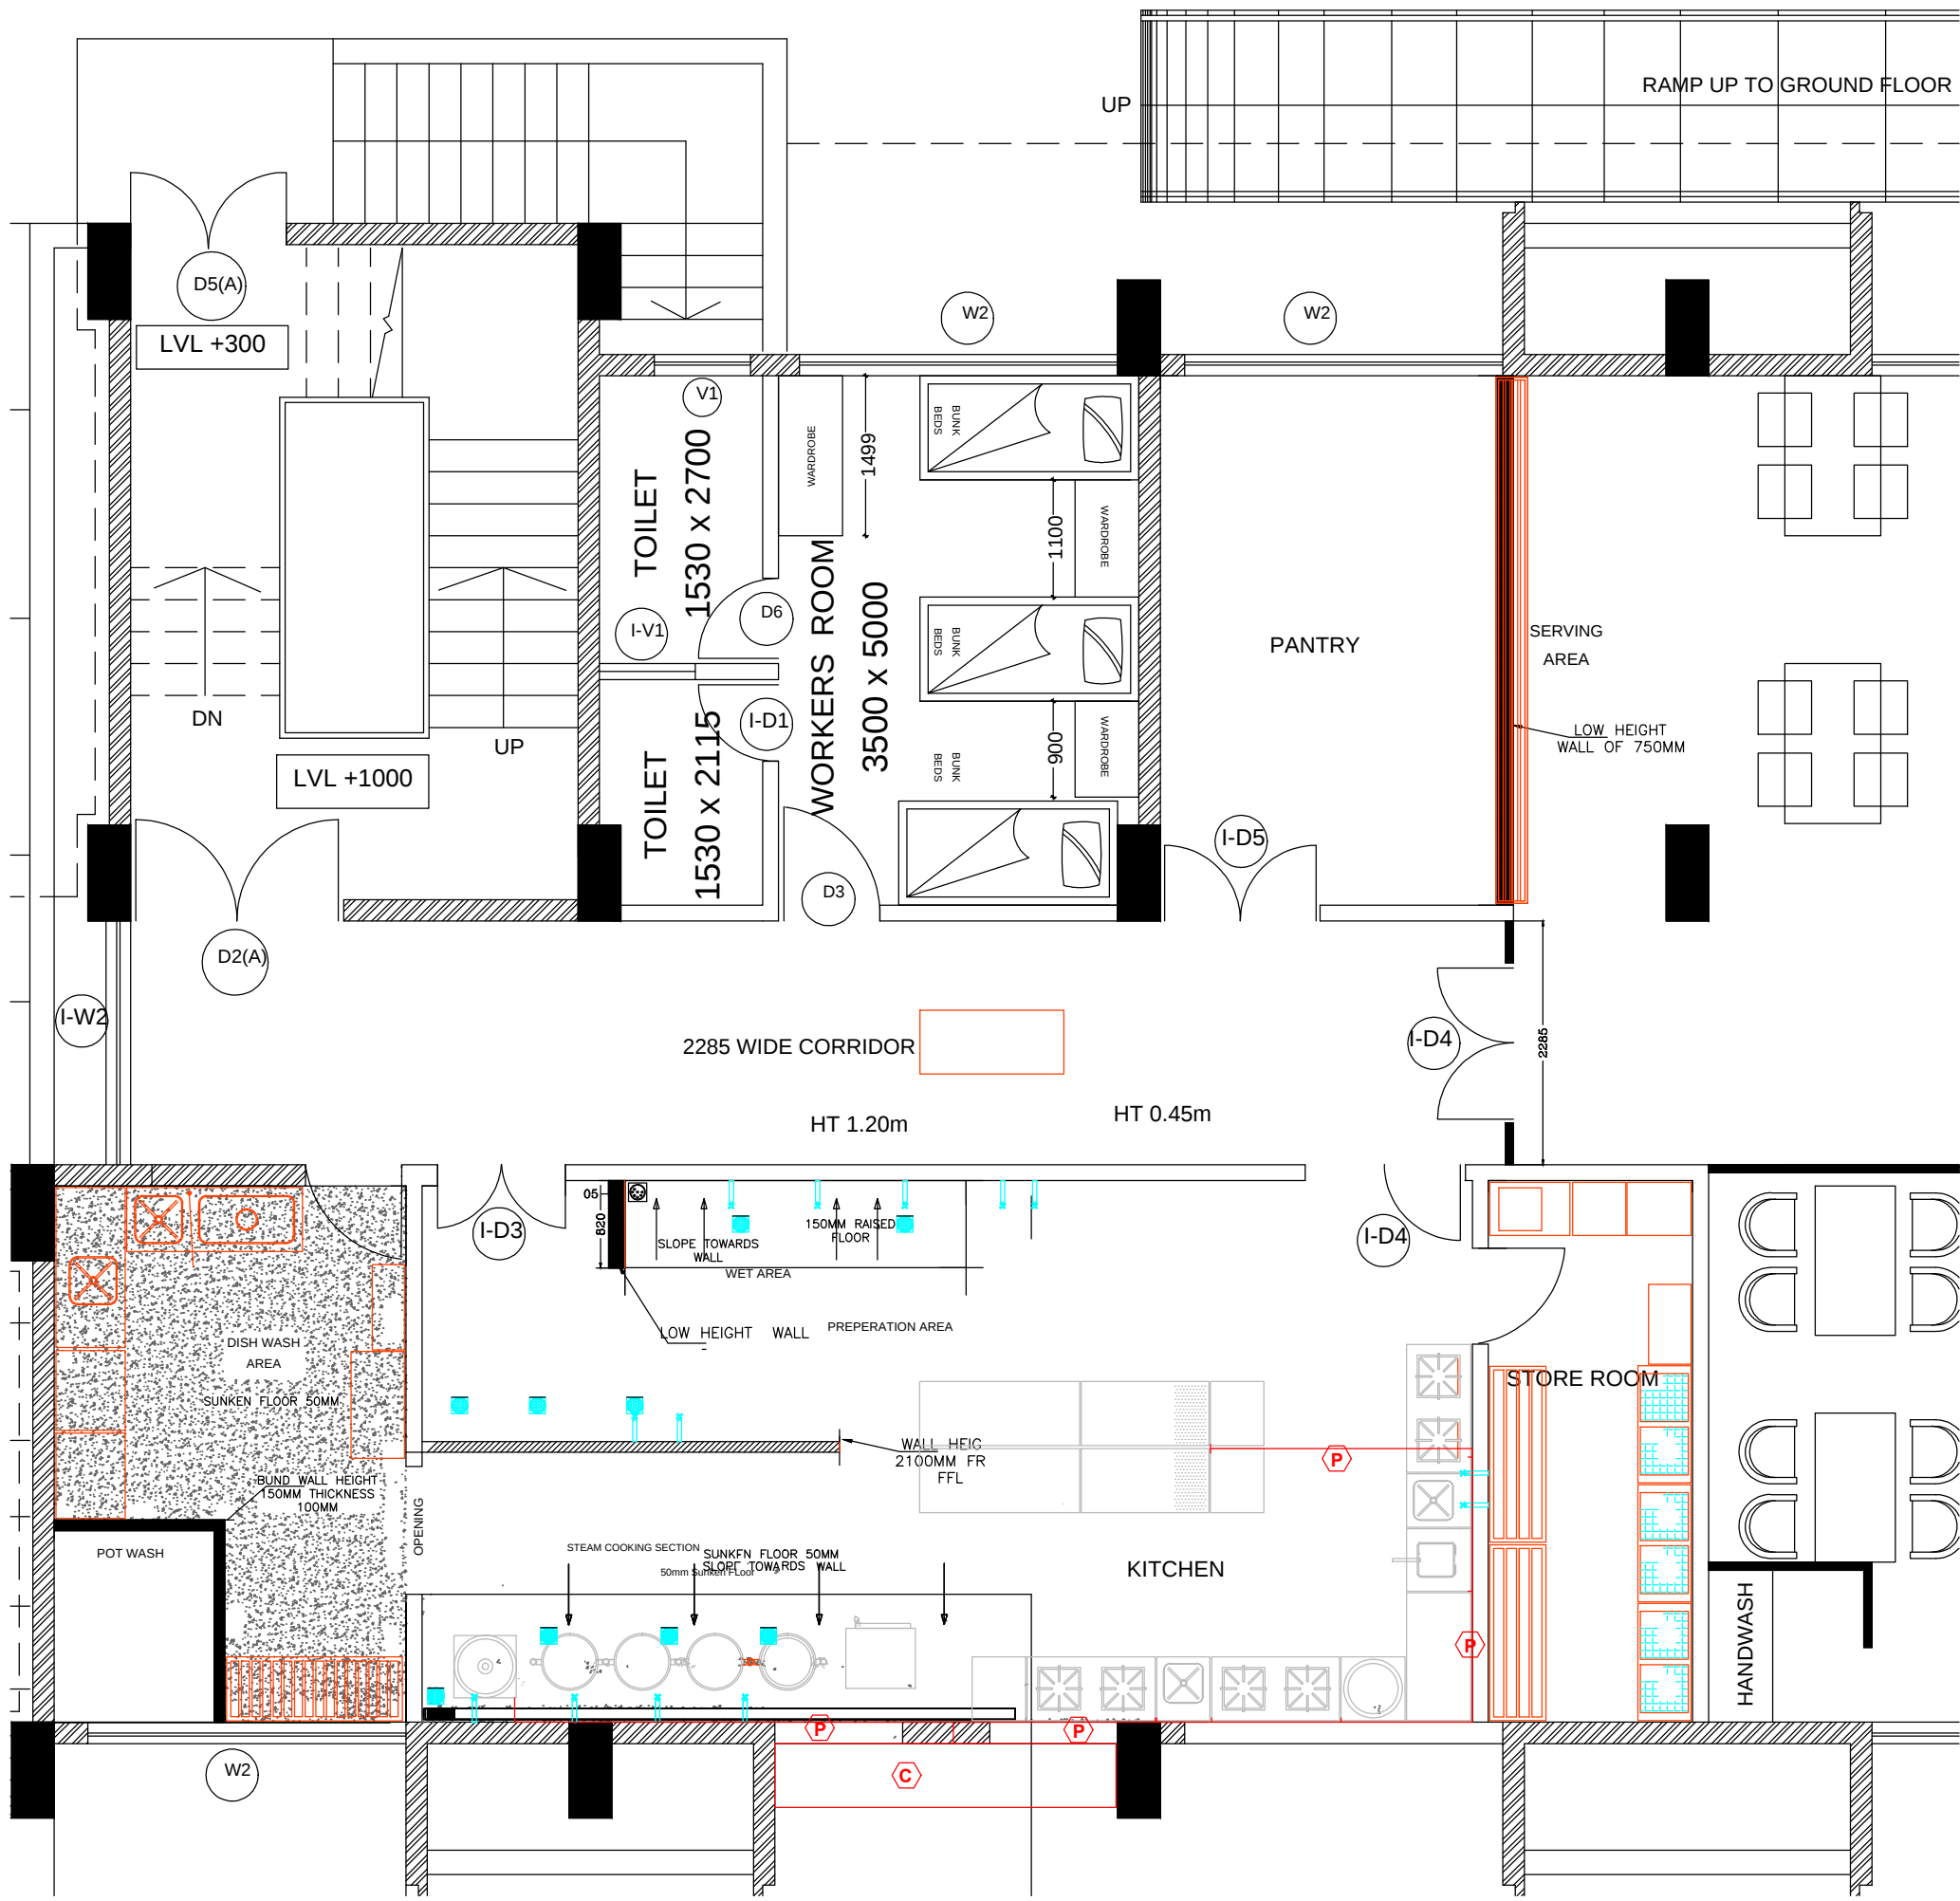

L.P. GAS PIPELINE LAYOUT

LEGEND

- C** Cylinder Cabinet, with 4 x 2 Manifold System.
- P** L. P. Gas Pipeline (12mm NB, M. S. 'C' Class Pipe (running at 300m from FFL))
- Gas Connection to Ept thr NCV & Flex Pigtail.

Proposed Kitchen facility at Currency Chest,
Canara Bank, Bagalur, Bengaluru.


Drawing No: CB/04/23-24
Sheet No : 03
Date : 12/03/2024
Revision No :R0
Rev Date :



	Name
Drawn By	Naveen
Checked By	Ar.Anjali Udoshi

NAVEEN ENTERPRISES
AR. ANJALI N. UDOSHI
Architect, Interior and Landscape Designer.
#112,Laxmi layout,Gokul Road, Hubli.
Hello : M- 9448061435,
email: enterprisesnaveen2005@gmail.com

CIVIL LAYOUT

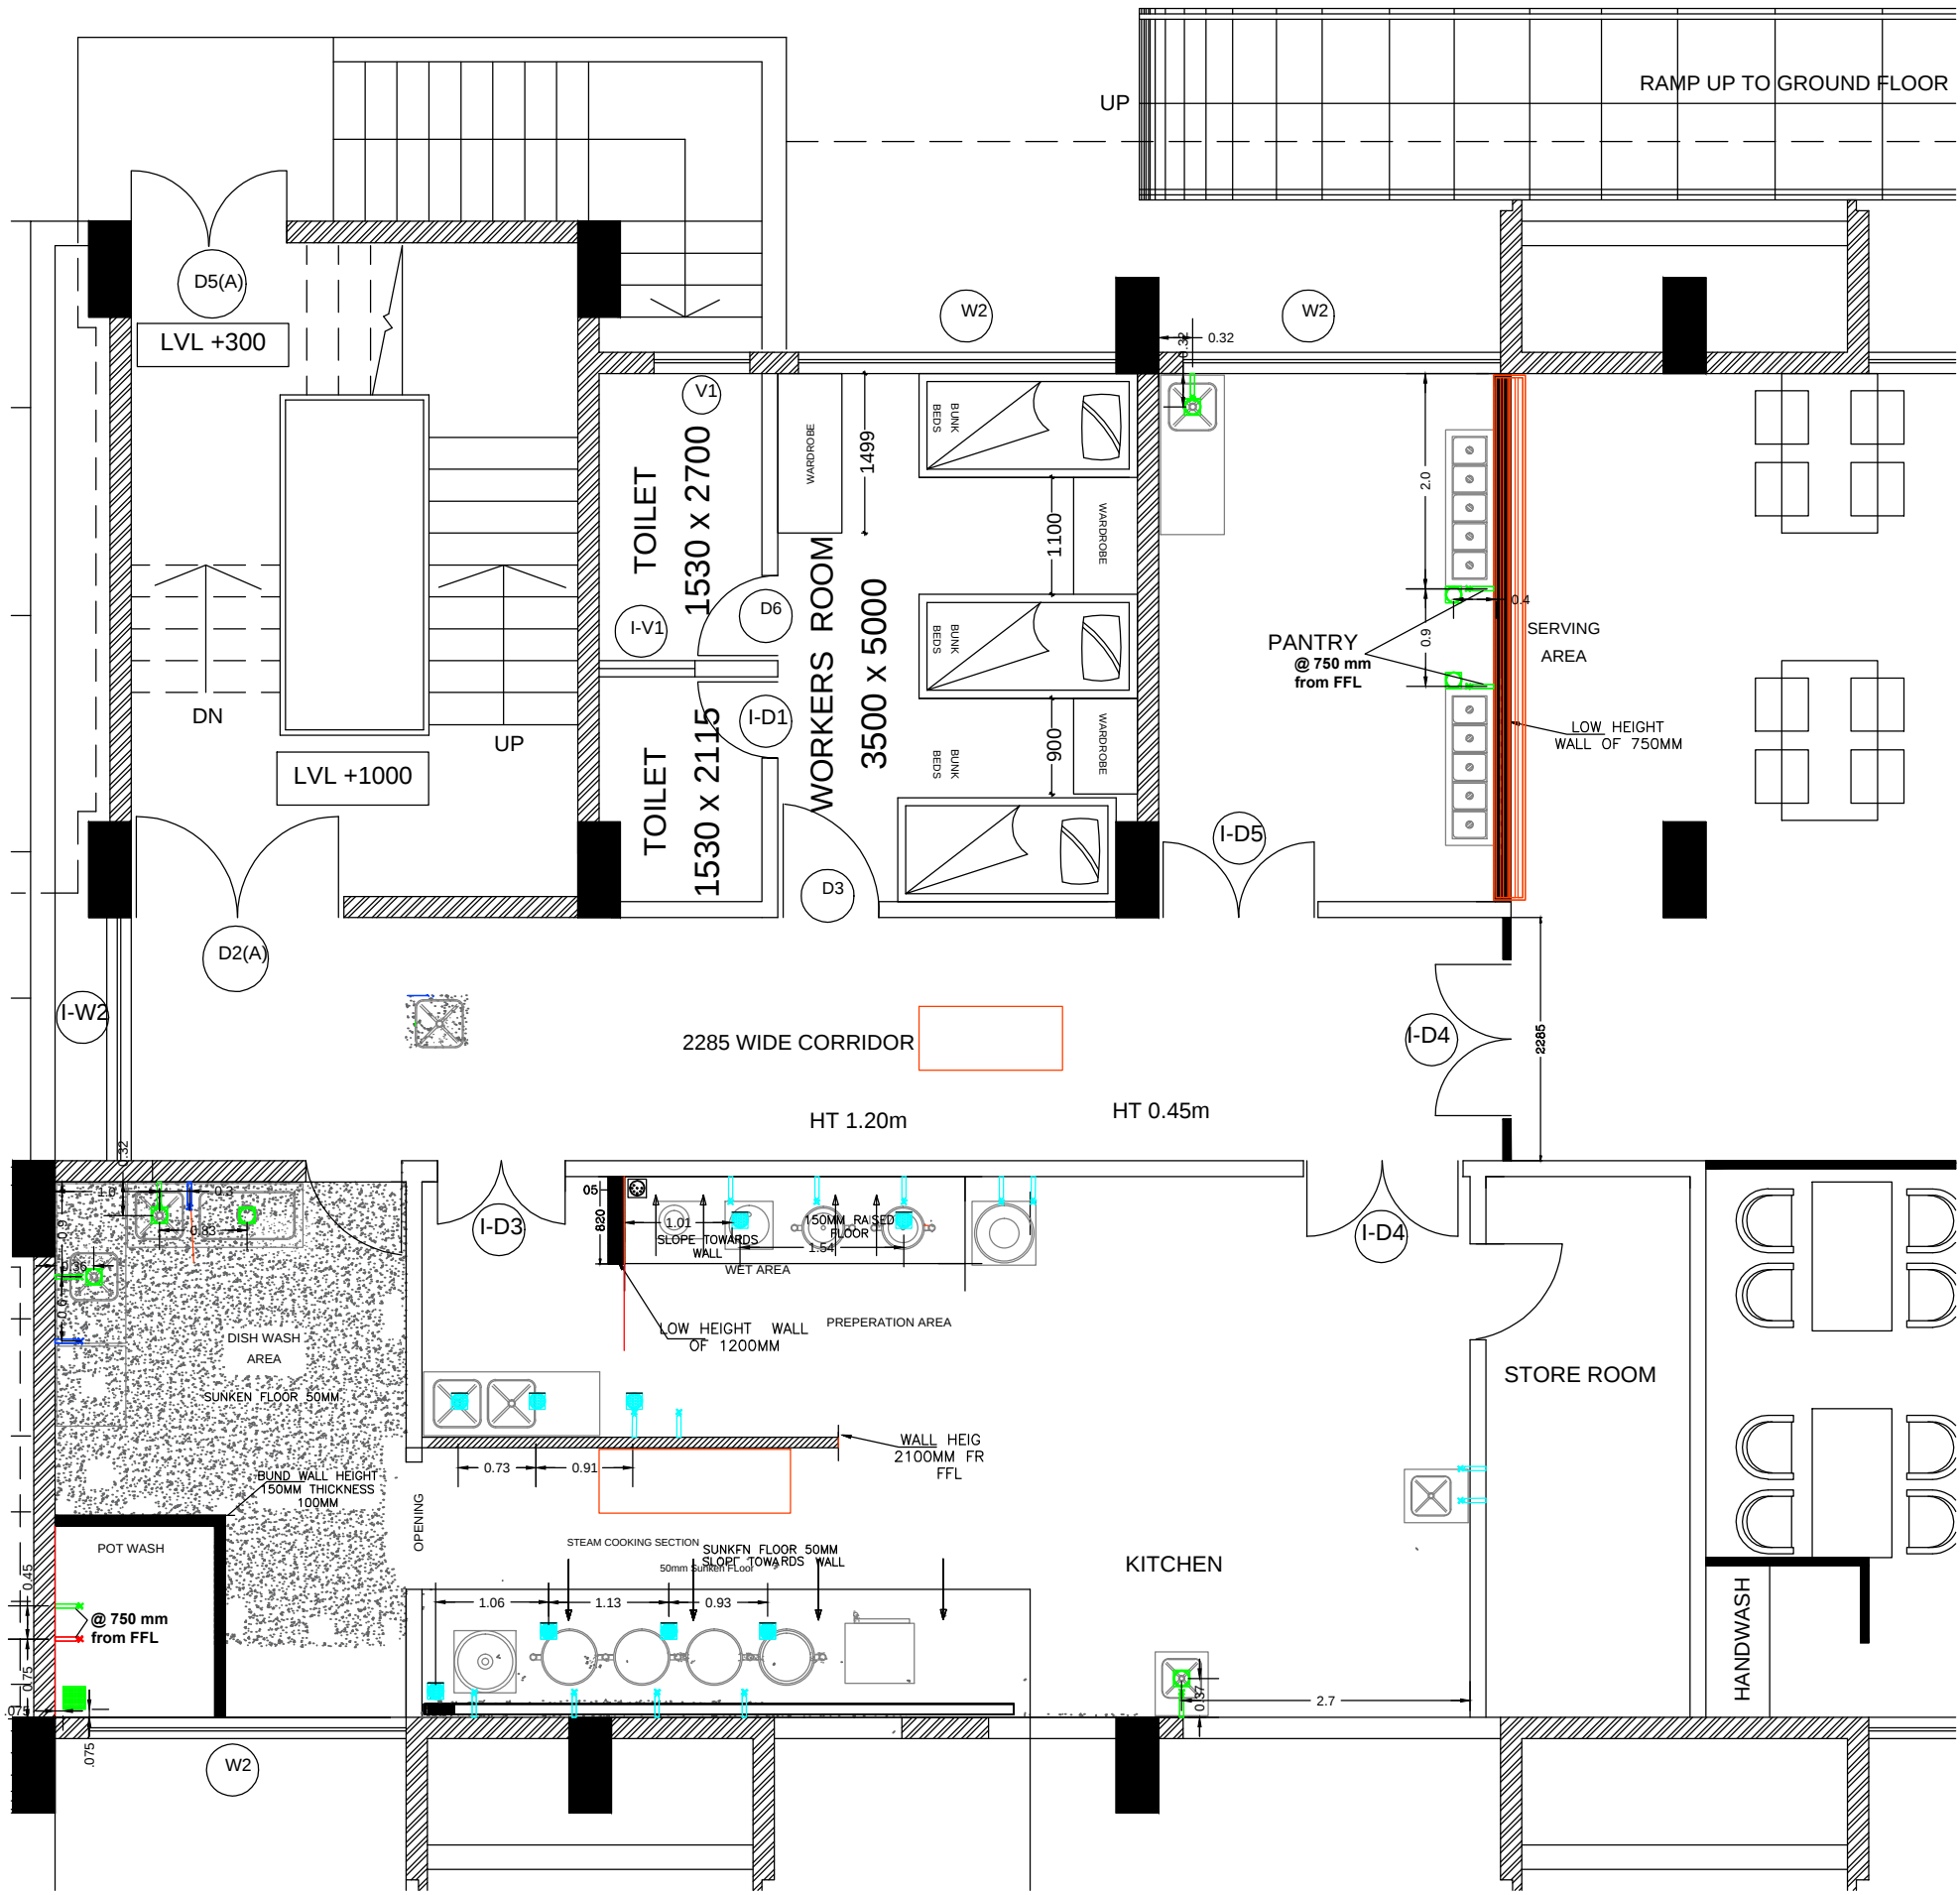

LEGEND

- 1" Cold Water Tap @ 1100 from FFL (Existing)
- Nahni Trap @ FFL (Existing)
- 3/4" Tap @ 1100 from FFL (New)
- 1" Hot Water Tap @ 750/1100 from FFL (New)
- 1" Cold Water Tap @ 750/1100 from FFL (New)
- 100x100mm Nahni Trap @ FFL (New)
- 200x200mm Gully Trap @ FFL (New)

PLUMBING & DRAINAGE LAYOUT


Proposed Kitchen facility at Currency Chest,
Canara Bank, Bagalur, Bengaluru.

Drawing No: CB/04/23-24
Sheet No : 04
Date : 12/03/2024
Revision No :R0
Rev Date :



	Name
Drawn By	Naveen
Checked By	Ar.Anjali Udoshi

NAVEEN ENTERPRISES
AR. ANJALI N. UDOSHI
Architect, Interior and Landscape Designer.
#112,Laxmi layout,Gokul Road, Hubli.
Hello : M- 9448061435,
email: enterprisesnaveen2005@gmail.com

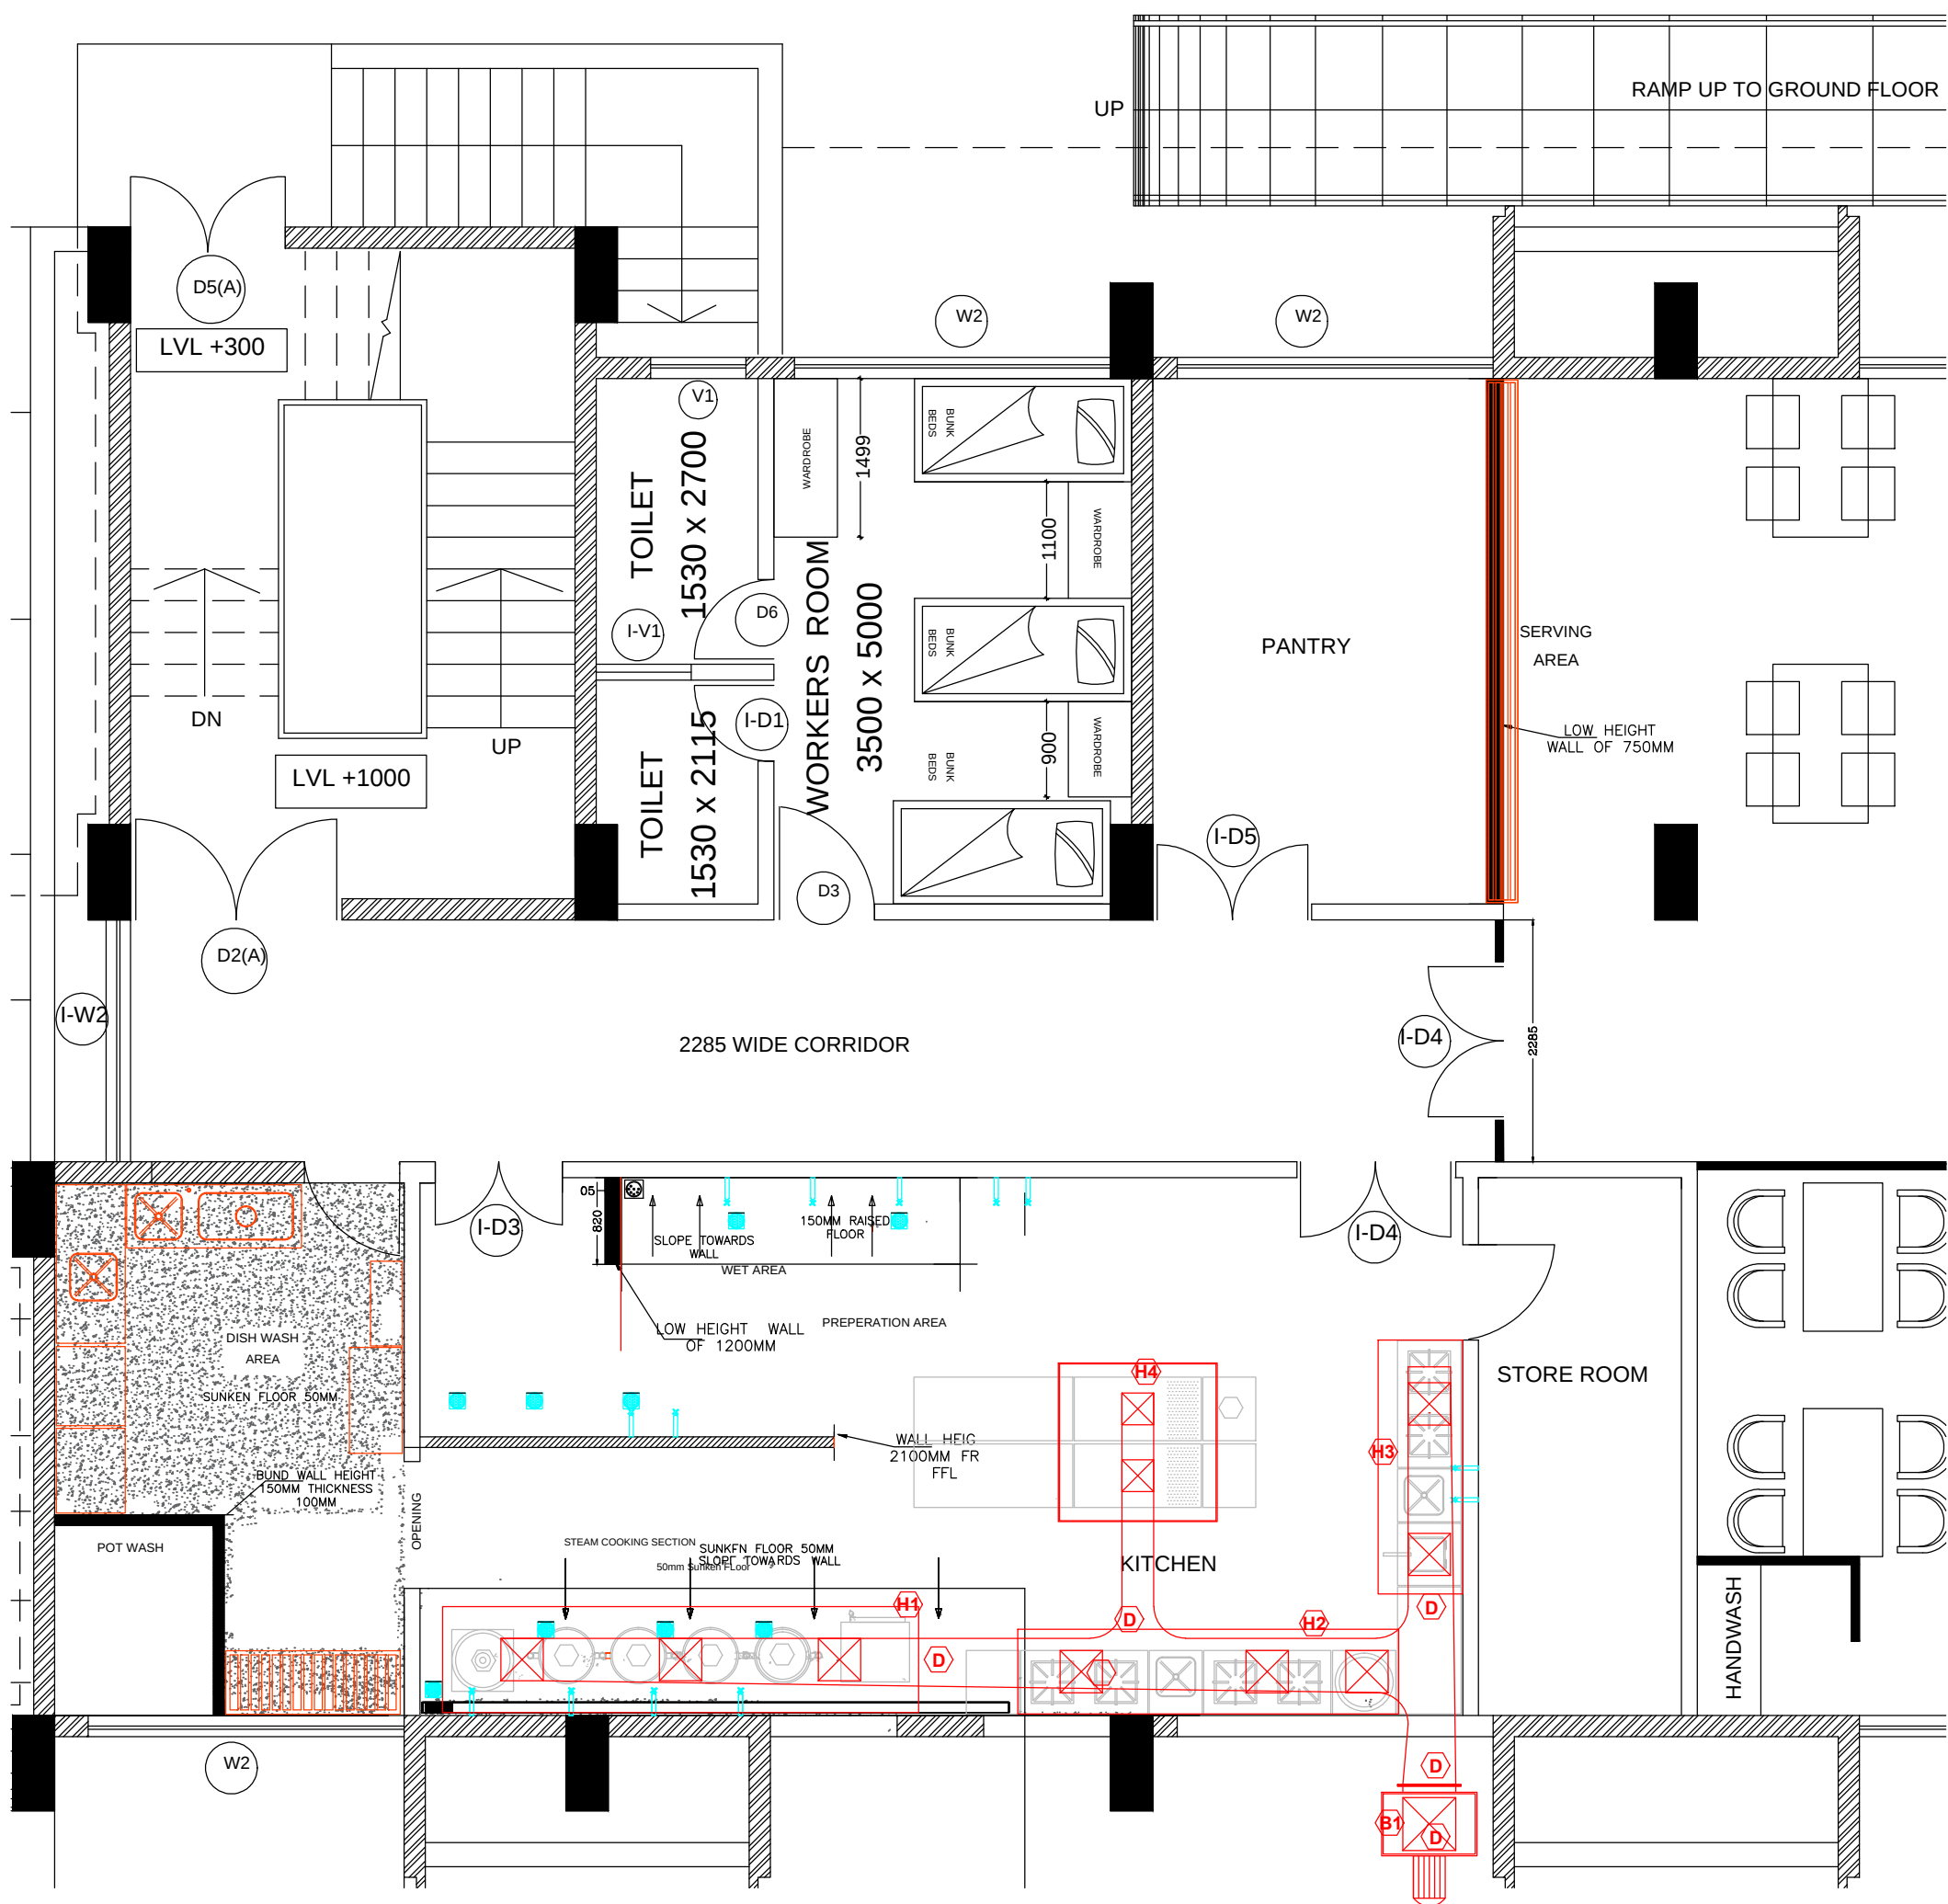

VENTILATION SYSTEM LAYOUT

LEGEND	
B1	Centrifugal Blower 7.5HP
D	G. I. Ducting
H1	S. S. Hood with Baffle Filters 4500x1000x500mm ht.
H2	S. S. Hood with Baffle Filters 3600x800x500mm ht.
H3	S. S. Hood with Baffle Filters 2400x800x500mm ht.
H4	S. S. Hood with Baffle Filters 1500x1500x500mm ht.

Proposed Kitchen facility at Currency Chest, Canara Bank, Bagalur, Bengaluru.

Drawing No: CB/04/23-24
Sheet No : 02
Date :12/03/2024
Revision No :R0
Rev Date :



	Name
Drawn By	Naveen
Checked By	Ar.Anjali Udoshi

NAVEEN ENTERPRISES
AR. ANJALI N. UDOSHI
Architect, Interior and Landscape Designer,
#112,Laxmi layout,Gokul Road, Hubli,
Hello : M- 9448061435,
email: enterprisesnaveen2005@gmail.com