


Record Room
19'-7" X 10'-5"

road side
entrance to building

Gents Toilet
9'-3"x6'-0"

Ladies Toilet
3'-7"x9'-5"

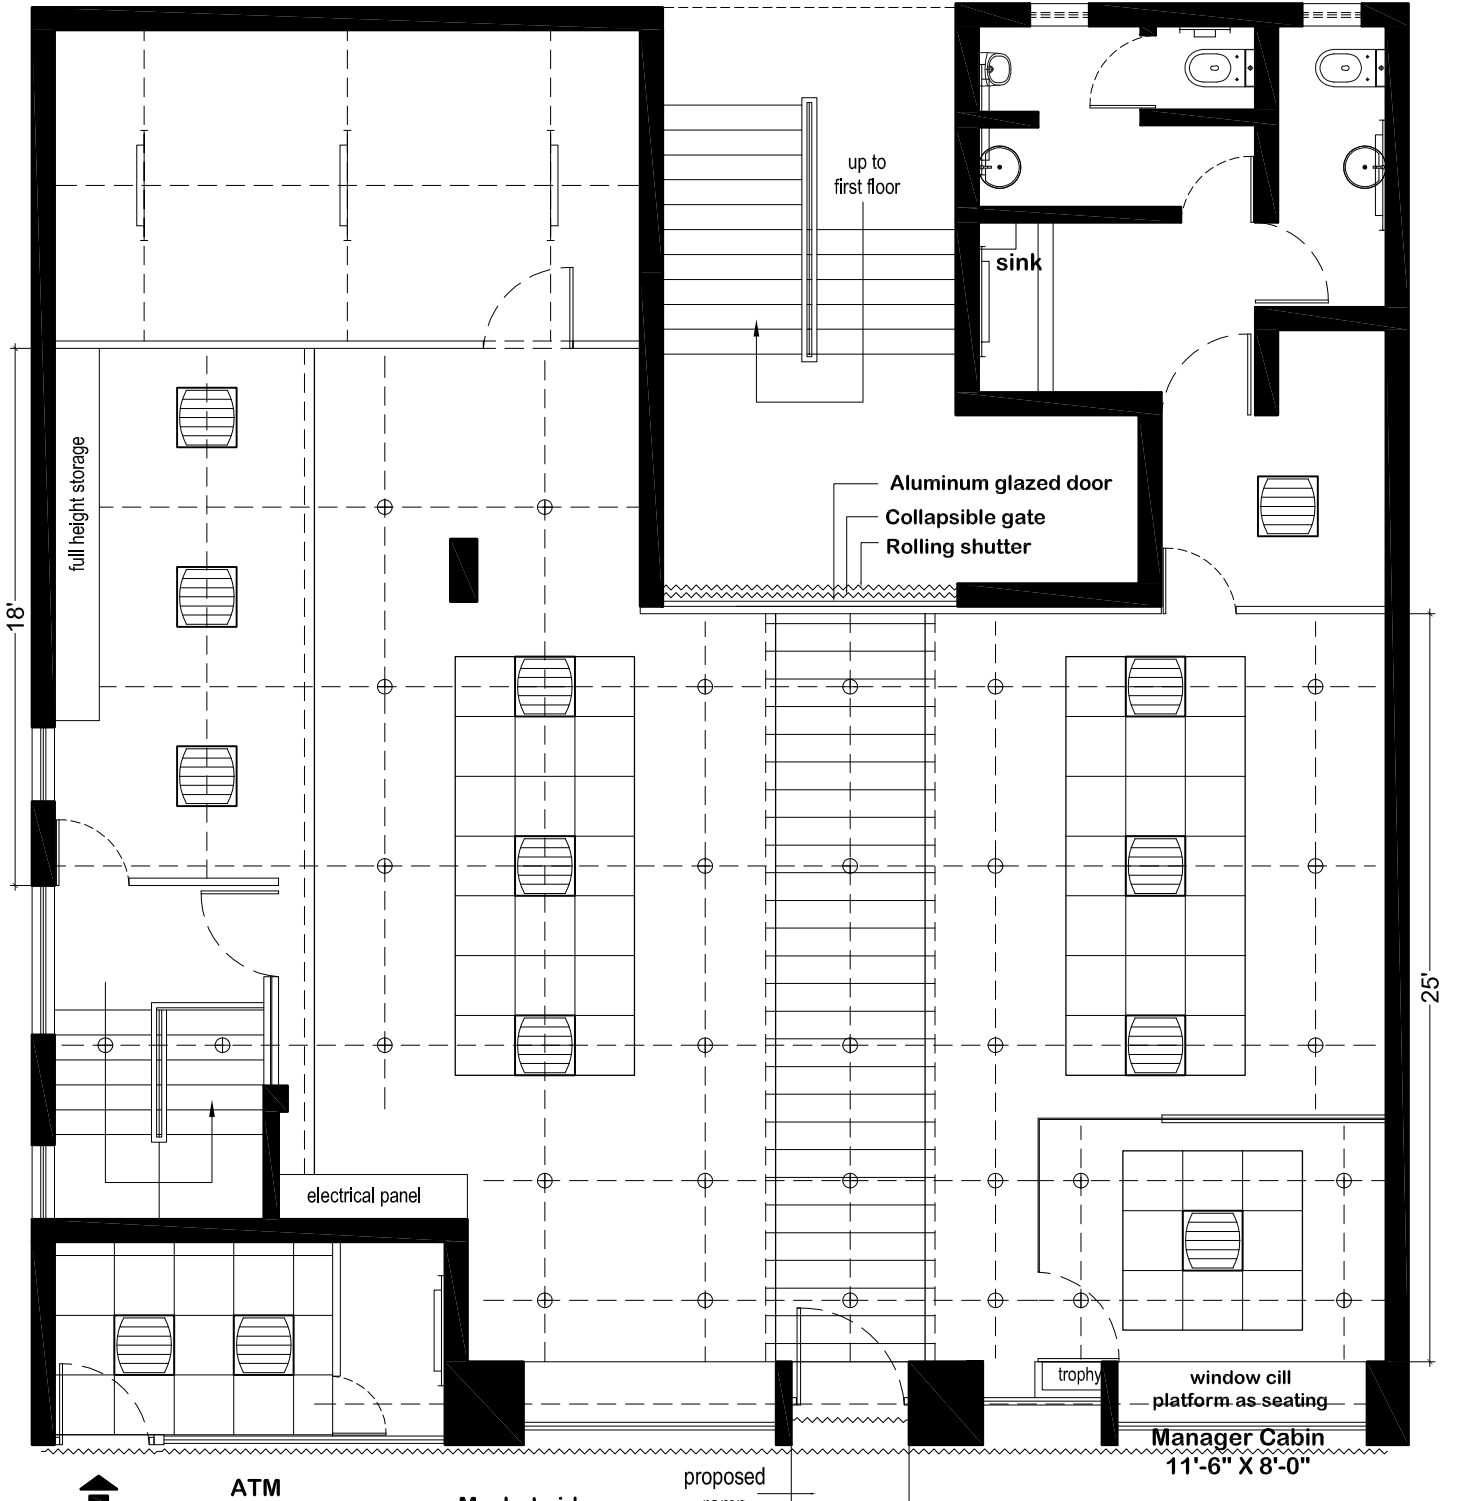

LEGEND

SN.	SYMBOL	DESCRIPTION	nos.
1		600X600 LIGHT	13
2		DOWN LIGHTER	31
3		BATTEN LIGHT	16
3		STRIP LIGHT	25M



CANARA BANK
SAKET BRANCH,
NEW DELHI

Drawing Title:
LIGHTING PLAN- GROUND FLOOR

Date:
13/05/2024

Drawing No.:
CN/NO/AD/02

GEOTECH TECHNICAL ASSOCIATES
G T A

B-004, Amrapali Princely Estate, Sector - 76, Noida - 201301
ph.: 9818938150, 9910297218
e-mail: technicalassociates9@gmail.com