


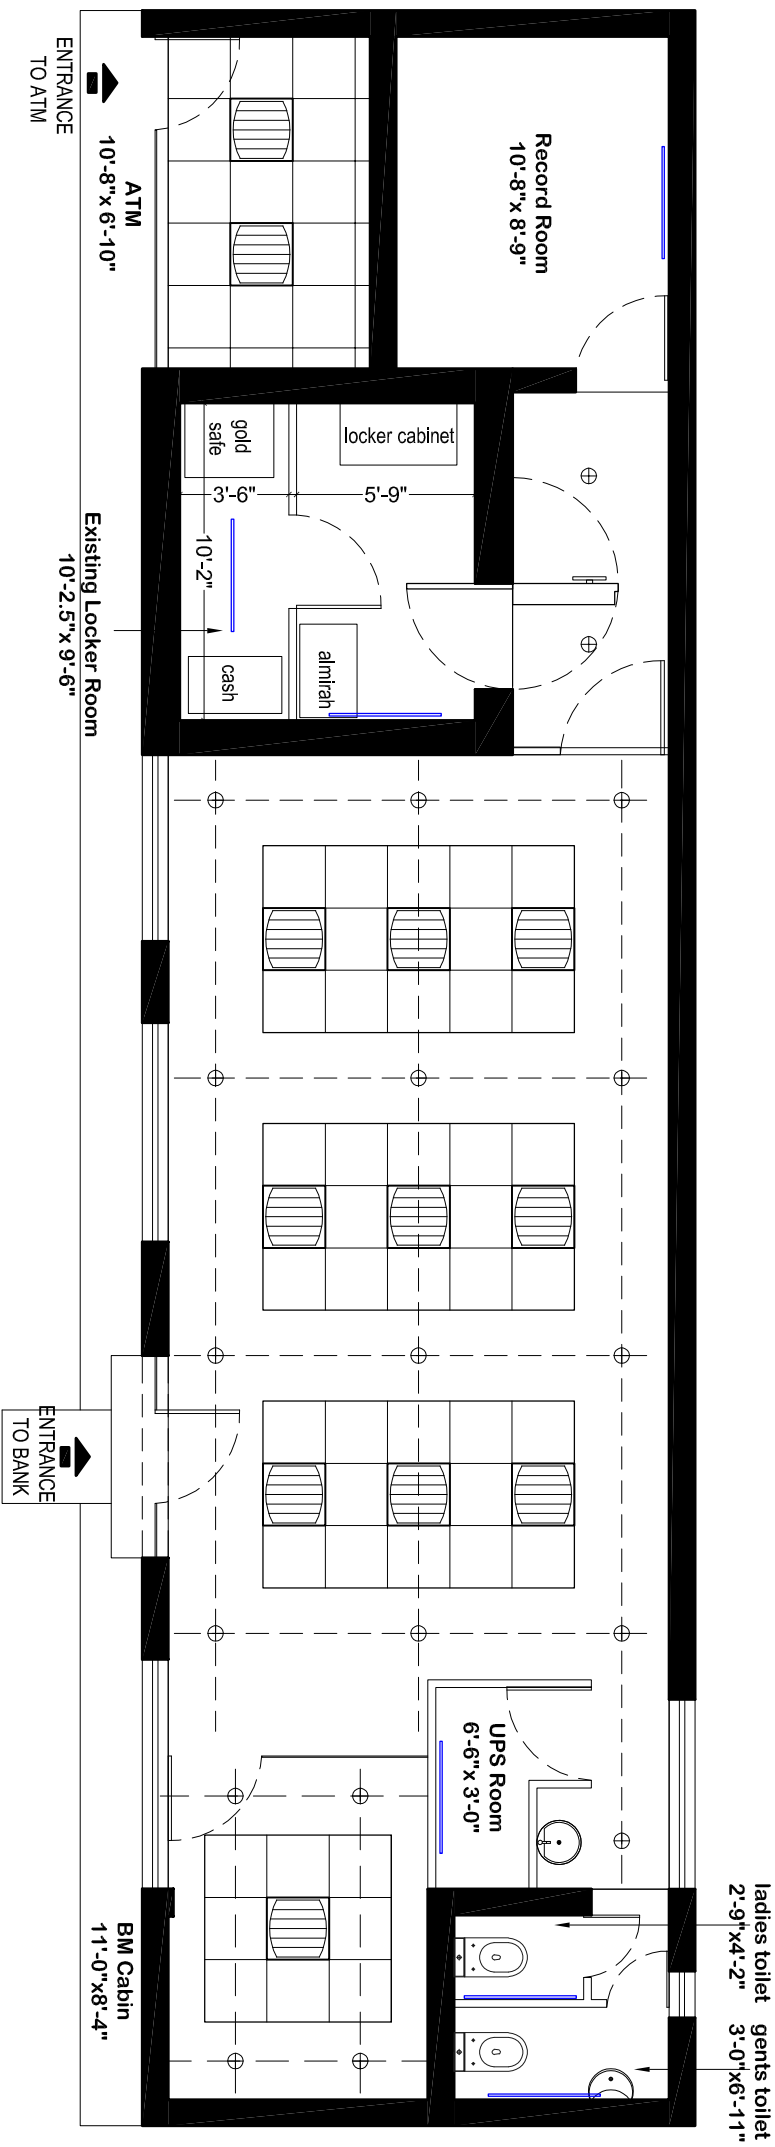

LEGEND

S.No.	SYMBOL	DESCRIPTION	Nos.
1	⊕	DOWN LIGHTER	19
2	—	T- 5	06
3		600X600 DOWN LIGHT	12
4	---	STRIP LIGHT	00



NORTH



CANARA BANK
SUNCITY BRANCH,
GURUGRAM

Drawing Title:
LIGHTING PLAN
Date:
22/04/2024

Drawing No.:
CN/GU/AD/02

GEOTECH TECHNICAL ASSOCIATES
B-004, Amrapali Pinyoli Estate, Sector - 76, Noida - 201301
ph.: 9818938150, 9810287218
e-mail: technicalassociates@gmail.com

OPTION -1