


THIS DRAWING IS THE PROPERTY OF NARENDRA SARDESHPANDE & ASSOCIATES AND ITS USE IN ANY MANNER BY ANY PERSON WITHOUT PERMISSION IS PROHIBITED.

NOTES :-

1. ALL LEVELS ARE FINISHED FLOOR LEVELS UNLESS OTHERWISE MENTIONED.
2. THE ARCHITECTURAL WORKING DRAWINGS MUST BE COORDINATED WITH THE RELEVANT DRAWING FROM OTHER CONSULTANTS BEFORE EXECUTION. ANY DISCREPANCY MUST BE BROUGHT TO THE NOTICE OF THE ARCHITECT IMMEDIATELY.

NOTE : (UNLESS & UNTIL IT IS MENTIONED)

1. HT. OF GENETAL SWITCH & SOCKET(GSWB)=1350
2. HT. OF WALL BRACKET(WB)=2250
3. INVERTER BACK UP SHOULD BE PROVIDED FOR ELECTRICAL POINTS AS DECIDED
4. BOARD PLUG TO BE PROVIDED ON EACH SWITCH BOARD
5. HT. OF A.C. SOCKET = 2400.
6. HT. OF CSPB -(FOR COMPUTERS ON WORK STATION)
 - a. HT. OF SWITCH = 825
 - b. HT. OF 4 SOCKET = 450
 - c. HT. OF ALL TELEPHONE(TEL) & DATA = 300
 - d. COMPUTER SOCKET SHALL BE BELOW WORKING TOP & SWITCH SHALL BE ABOVE WORKING TOP.
 - e. RAW POWER SW+SOCKET=825.

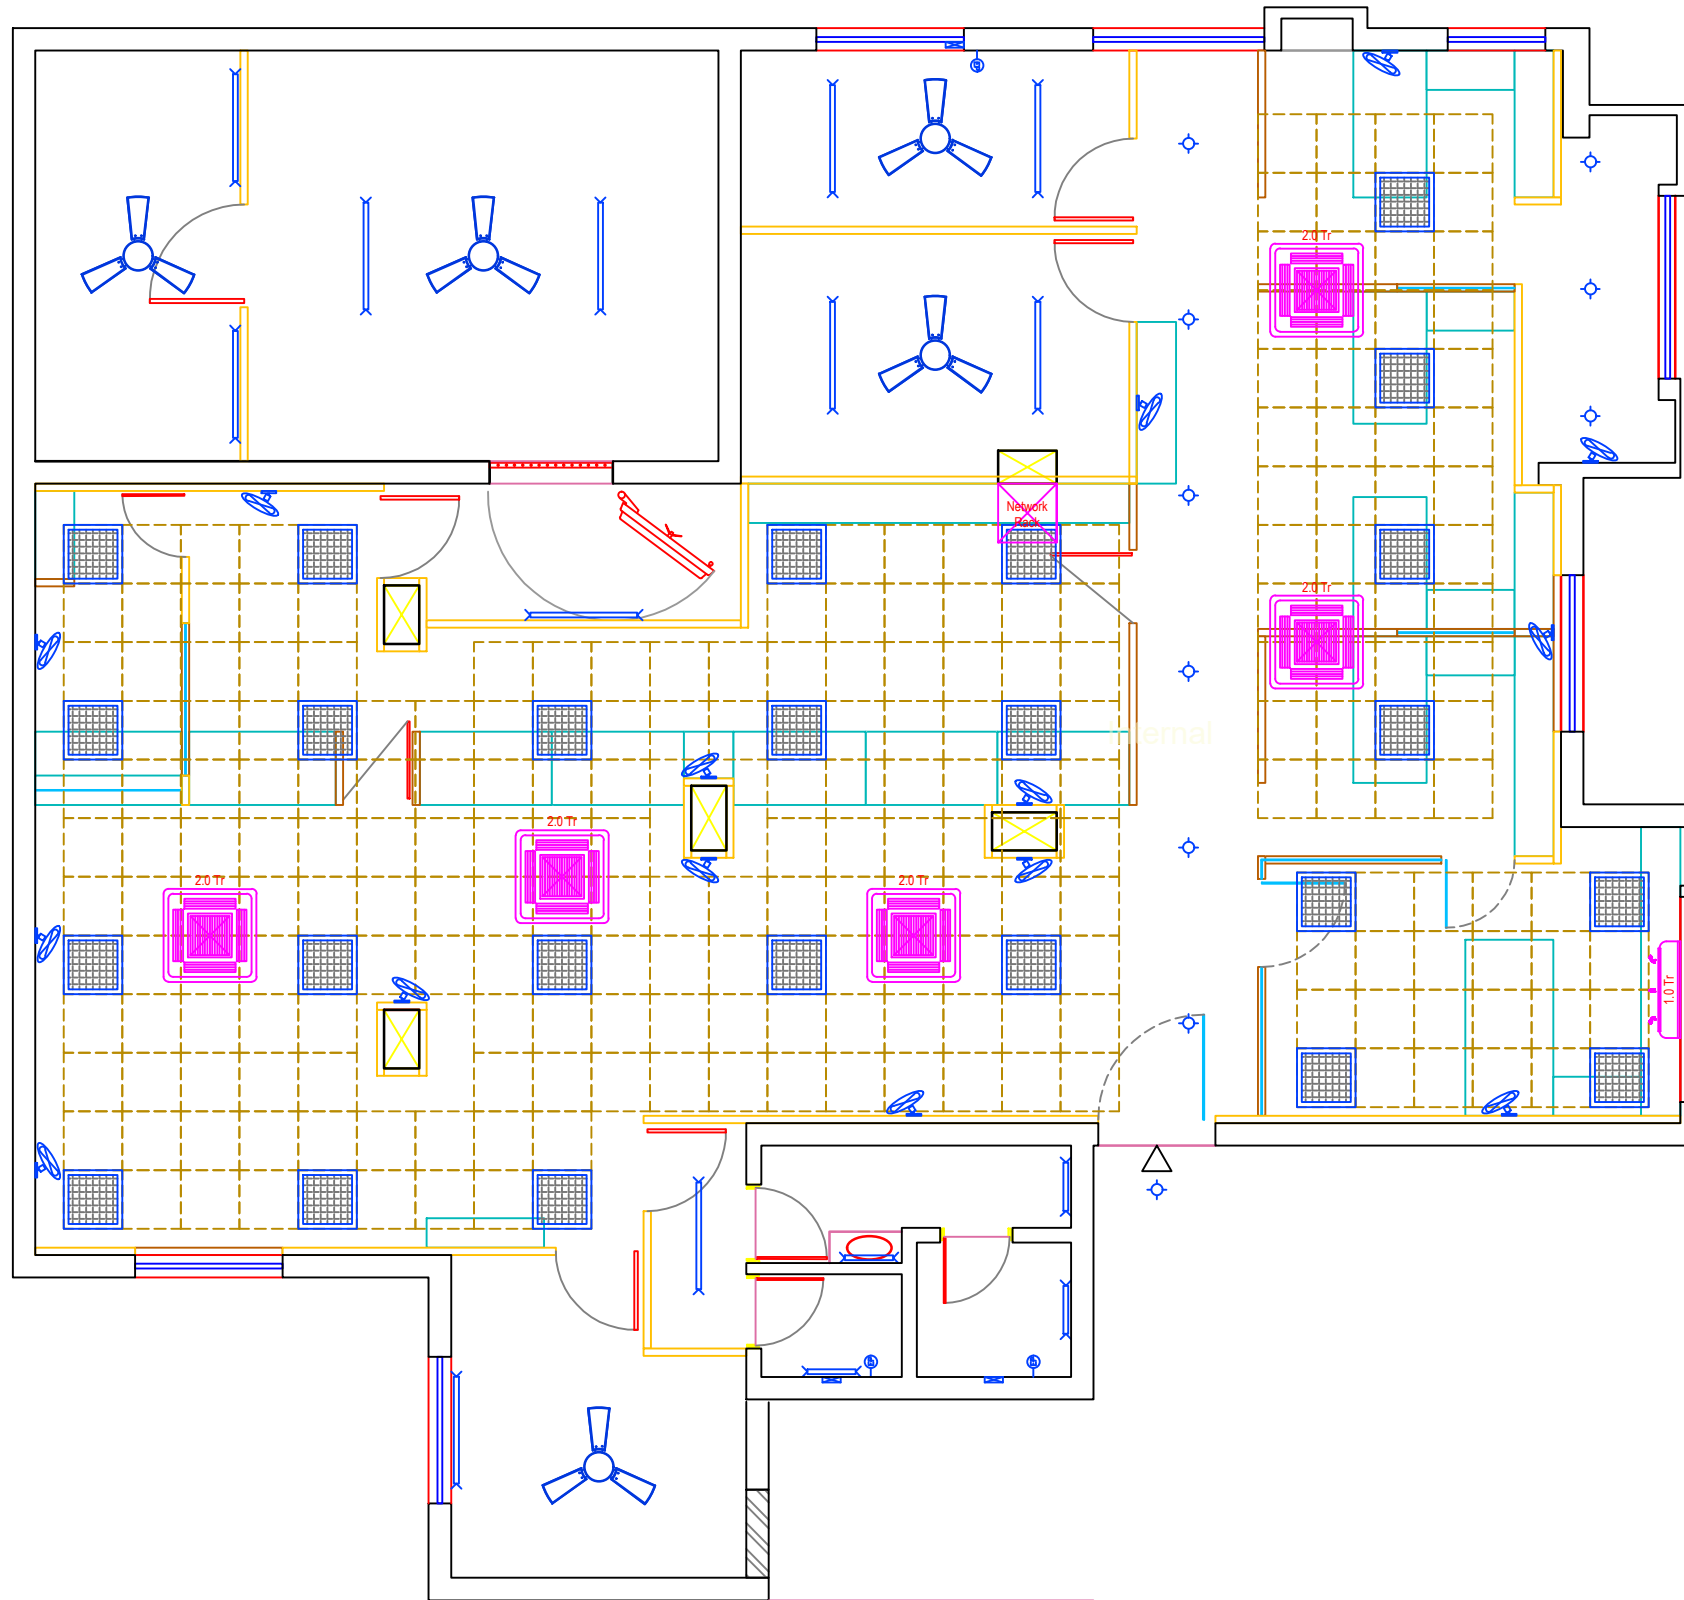

ELECTRICAL FIXTURES

○	WALL BRACKET	⊗	CEILING FAN
⊙	CEILING LIGHT	⊖	WALL FAN
⊕	CEILING LIGHT -UPS	⊖	SPLIT A.C.
⊖	2'X2'LIGHT FIXTURE	⊖	CASSET A.C.
⊖	2'X2'LIGHT FIXTURE-UPS	⊖	
⊖	TUBE LIGHT	⊖	EXHAUST FAN
⊖	TUBE LIGHT -UPS	⊖	EXHAUST FAN PT.
⊖	WATERPROOF LIGHT	⊖	BELL PUSH
⊖	RECESSED FOOTLIGHT	⊖	BELL BUZZER
⊖	METER BOARD	⊖	TELEPHONE
⊖	DISTRIBUTION BOARD	⊖	TV + CABLE PT.
⊖	RJ-45,DATA - I/O	⊖	SPEAKERS

SECURITY SYSTEM

⊖	CCTV CAMERA - Bullet type
⊖	CCTV CAMERA - Dome type
⊖	HEAT DETECTOR
⊖	SMOKE DETECTOR BELOW FALSE CEILING
⊖	SMOKE DETECTOR ABOVE FALSE CEILING
⊖	RESPONSE INDICATOR
⊖	HOOTER

ELECTRICAL POWER POINTS


⊖	6 AMPS. SWITCH & SOCKET
⊖	6 AMPS. SWITCH & SOCKET ON UPS
⊖	16 AMPS. SWITCH & SOCKET
⊖	16 AMPS. SWITCH & SOCKET ON UPS
⊖	6 AMPS. THREE SOCKET WITH 6A SWITCH
⊖	6 AMPS. UPS THREE SOCKET WITH 6A SWITCH
⊖	20 AMPS. SWITCH & SOCKET

PROJECT: - **PROPOSED INTERIOR DESIGN OF AADAT BRANCH**

CLIENT:- **CANARA BANK**

SITE: - **AHMEDNAGAR**

NSA
NARENDRA SARDESHPANDE & ASSOCIATES
Architects
 43, 'Shreeku', Flat No.2, Ground Floor, United Western Reg. Society, Near Tothowade Garden, Karvenagar, Pune-411002
 Tele--(020) 2545 42 97. E-mail : nsapune1@gmail.com

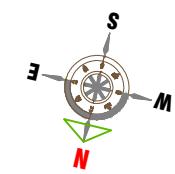

DRAWING CATEGORY		SHEET	
		ELECTRICAL LAYOUT	
L	(6-)	01	R1
SCALE		SCALE	
1:75		1:75	
JOB NO.	DATE	DRAWN BY	REVISED BY
223-38	06.06.2024	NS	