


Slab -3.00M
BEAM-2.63M

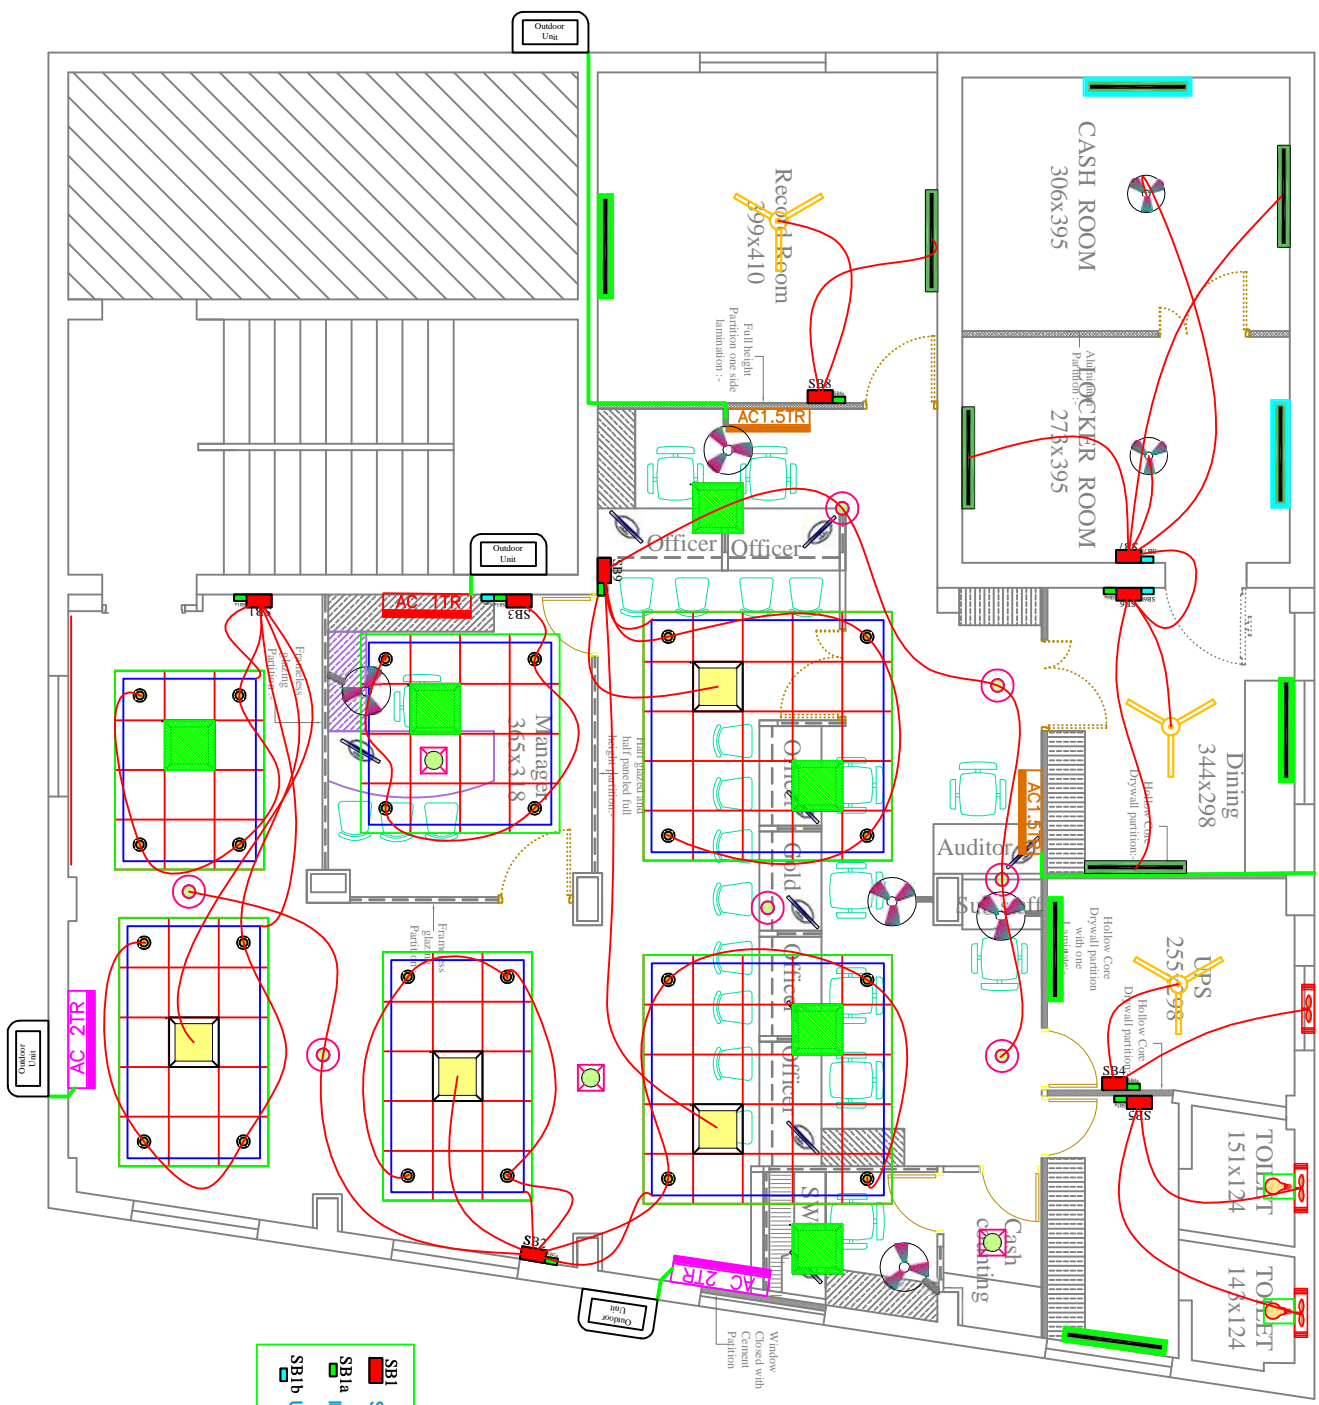

■ SBI SWITCH BOARD
■ SBIa INVERTER SWITCH BOARD
■ SBIb UPS SWITCH BOARD

S.No	Rev	Date	Remarks	Sign	Check
1					
2					
3					
4					
5					
6					
7					
8					
9					
10					
11					
12					
13					
14					
15					
16					
17					
18					
19					
20					
21					
22					
23					
24					

Revisions

S.No	Rev	Date	Remarks	Sign	Check
1					
2					
3					
4					
5					
6					
7					
8					
9					
10					
11					
12					
13					
14					
15					
16					
17					
18					
19					
20					
21					
22					
23					
24					

Scale : NTS Date : 28-09-2023

DC : Detail :

Checked : Sujesh Drawn By: Roshan

Drawing No : 2 Job no :

ALL DIMENSIONS ARE IN CENTIMETERS

Title : CANARA BANK KATTAPPANA

Name of work: PROPOSED ELECTRICAL LAYOUT

Clients Signature-

Client: Canara Bank Regional Office Kottayam

Architects Signature & seal :-

Architect: *Prima-shah*

Head office: (Architect, CA-84 8733 REG Value-F-3047) 359 - E, 1st Floor, Convent Road, Cherthala - 688 524 PH - 0478 - 2820159 E-mail primaarch@gmail.com