

	LED 2x2 LIGHT
	18W LED DOWN LIGHT
	WALL FAN
	LED SINGLETUBE
	EXHAUST FAN
	CEILING FAN
	ANGLE HOLDER WITH BULB
	LED STRIP LIGHT

LEGEND	
	PROPOSED BRICK WORK
	EXISTING BRICK WORK
	CUPBOARD 75 CM HEIGHT
	CUPBOARD 210 CM HEIGHT
	FULL GLAZED PARTITIONS
	DOUBLE SKIN SOLID GLAZED PARTITIONS
	SOLID PARTITIONS
	SEMI PARTITIONS (210 cm ht.Half glazed)
	SEMI PARTITIONS(120 cm ht.Half glazed)
	FIRE RATED CEMENT PARTITION


ENARC CONSULTANTS
ARCHITECTS AND ENGINEERS
 M. G. Road, Thrissur - 1.
 Tel. : +91 (487) 2441901
 E-mail : office@enarc.net.in

PROPOSED INTERIOR FURNISHING
FOR BANKS CANARA BANK
KATTAKADA BRANCH
ELECTRICAL LIGHTING LAYOUT

Drawn By **Ar. ARUN VARGHESE M**
 Architect **Ar.PRAVEEN.P**
B. Arch.[Reg], A.I.I.A, A.I.I.I.D

Chief Architect
Ar. K. RAMAKRISHNAN
B.Sc.(Engg), F.I.E, C. Eng (I),
F.I.V , F.I.I.A. (Regd), A.I.I.I.D

Date : 13 -12 -2023
 Sheet No : 01
 Scale : N T S
 All Dimensions are in Cms.

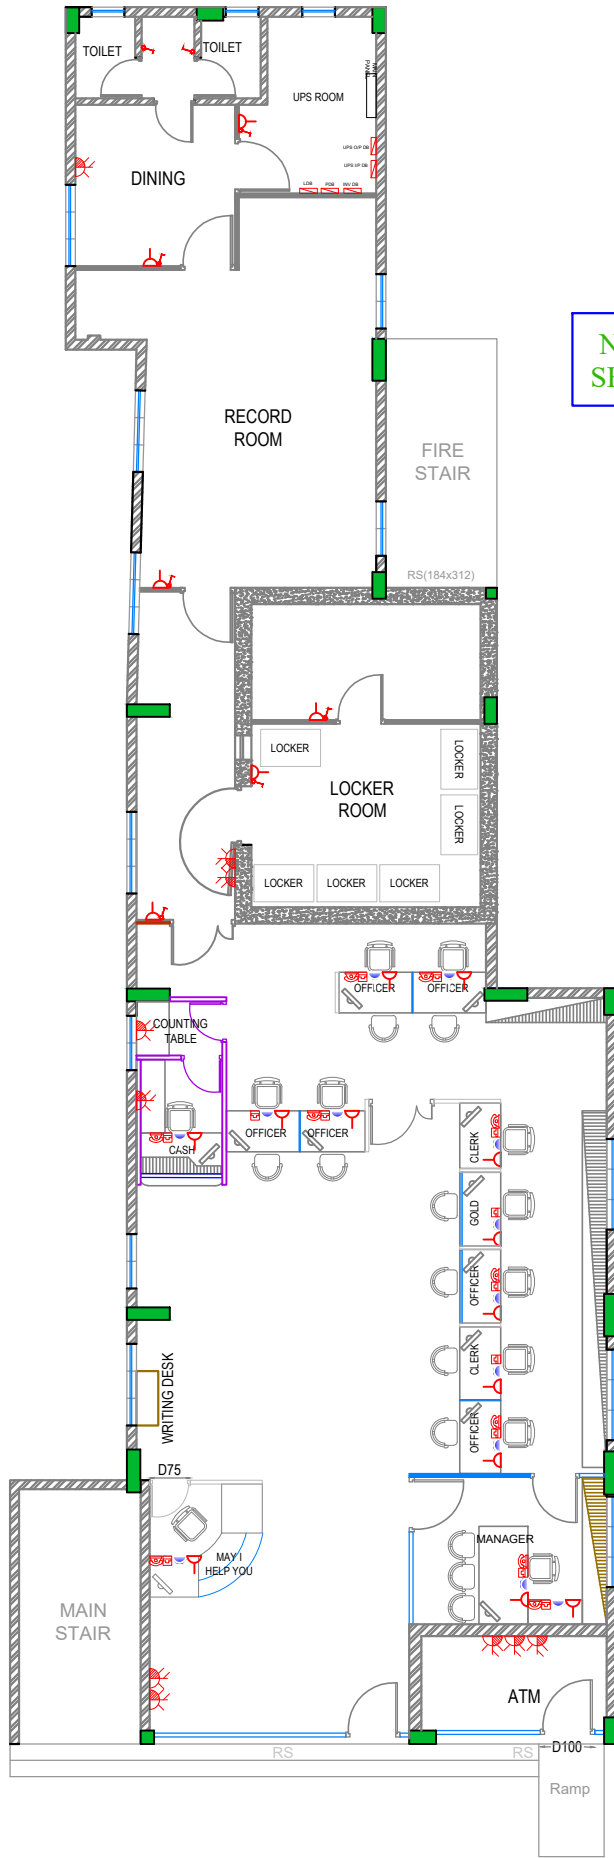

NOTE- NETWORK RACK POWER PLUG SHALL FIXED AT SUITABLE LOCATION

	6A SWITCH
	6A SOCKET WITH SWITCH
	16A SOCKET WITH SWITCH
	COMPUTER POINT
	DATA POINT
	TELEPHONE POINT

LEGEND	
	PROPOSED BRICK WORK
	EXISTING BRICK WORK
	CUPBOARD 75 CM HEIGHT
	CUPBOARD 210 CM HEIGHT
	FULL GLAZED PARTITIONS
	DOUBLE SKIN SOLID GLAZED PARTITIONS
	SOLID PARTITIONS
	SEMI PARTITIONS (210 cm ht. Half glazed)
	SEMI PARTITIONS (120 cm ht. Half glazed)
	FIRE RATED CEMENT PARTITION


ENARC CONSULTANTS
ARCHITECTS AND ENGINEERS
 M. G. Road, Thrissur - 1.
 Tel. : +91 (487) 2441901
 E-mail : office@enarc.net.in

PROPOSED INTERIOR FURNISHING FOR BANKS CANARA BANK KATTAKADA BRANCH
ELECTRICAL POWER LAYOUT

Drawn By **Ar. ARUN VARGHESE M**
 Architect **Ar.PRAVEEN.P**
B. Arch.[Reg], A.I.I.A, A.I.I.I.D

Chief Architect **Ar. K. RAMAKRISHNAN**
B.Sc.(Engg), F.I.E, C. Eng (I), F.I.V, F.I.I.A. (Regd), A.I.I.I.D

Date : 13-12-2023
 Sheet No : 01
 Scale : N T S
 All Dimensions are in C.Ms.

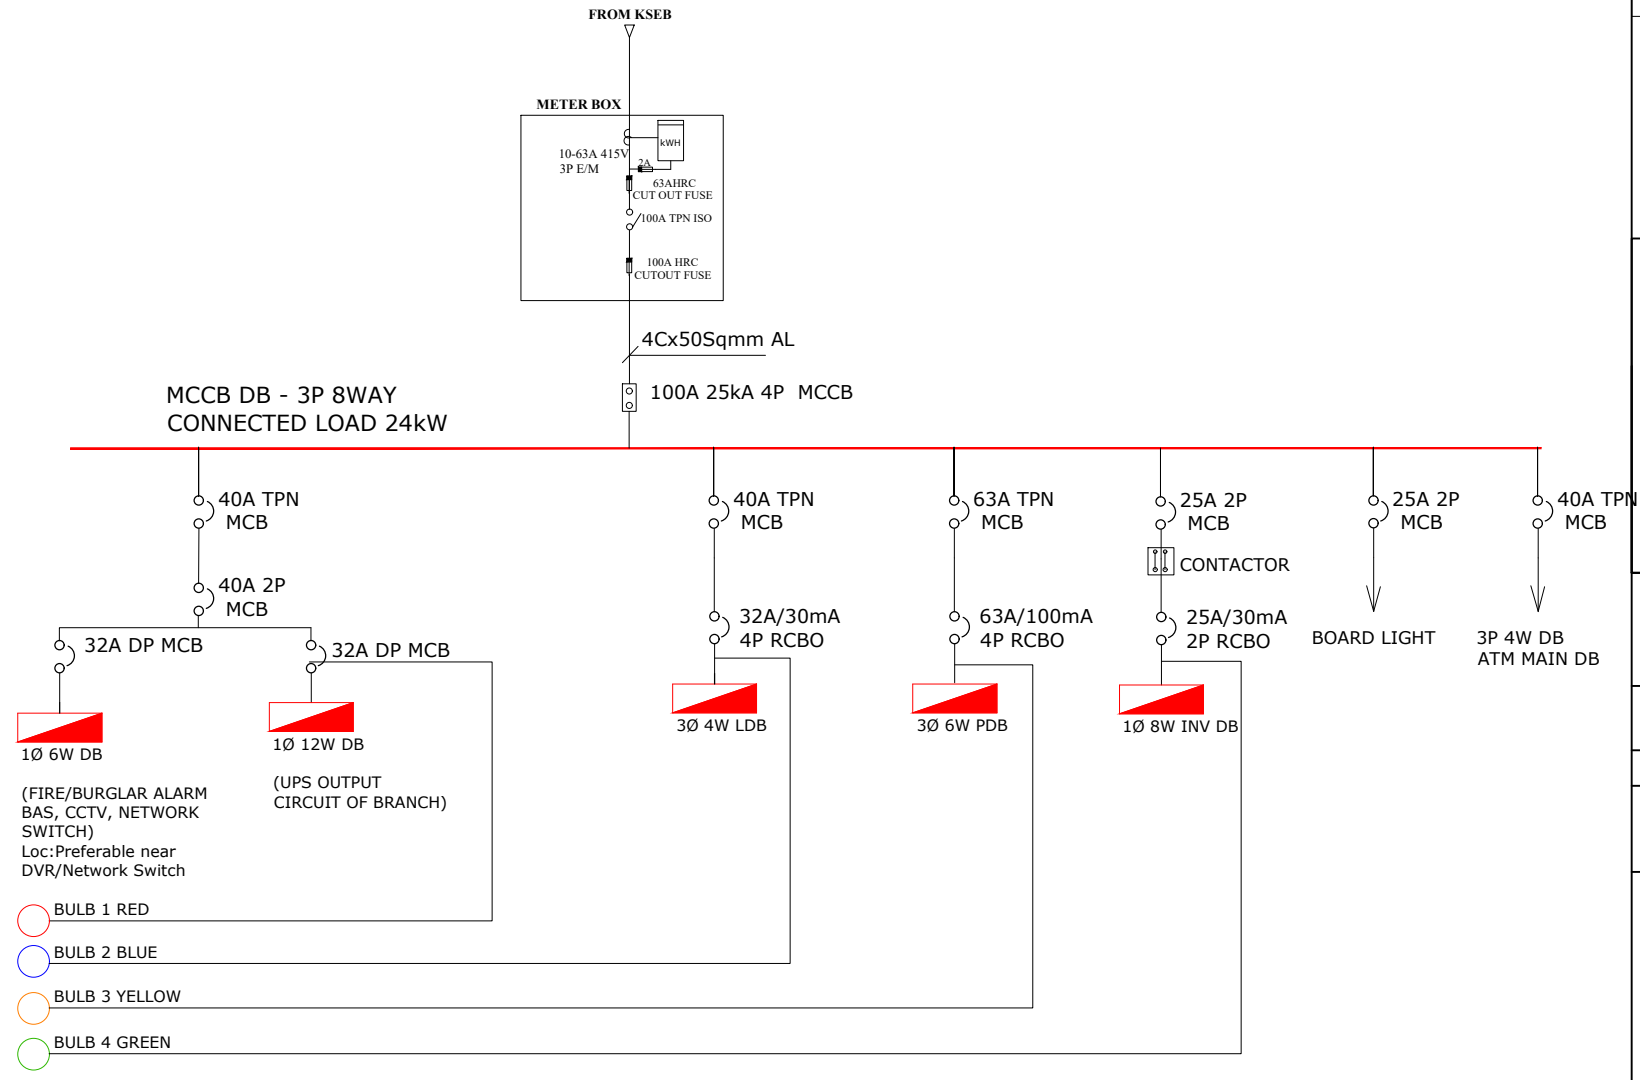

CANARA BANK KATTAKADA

METER BOARD TO MAIN PANEL


Drawn by	SHANAVAS	
Architect	Ar.PRAVEEN.P B. Arch.[Reg], A.I.I.A, A.I.I.I.D	
Chief Architect	Ar. K. RAMAKRISHNAN B.Sc.(Engg), F.I.E, C. Eng (I), F.I.V, F.I.I.A. (Regd), A.I.I.I.D	
Date	: 14 - 12 - 2023	12 - 04 - 2024
Scale	: NTS	
Sheet No	: 01	
Note: All Dimensions are in CMs.		

FROM MAIN PANEL

4Cx10Sqmm AL

32A/30mA
4P RCBO


3Ø 4W LDB

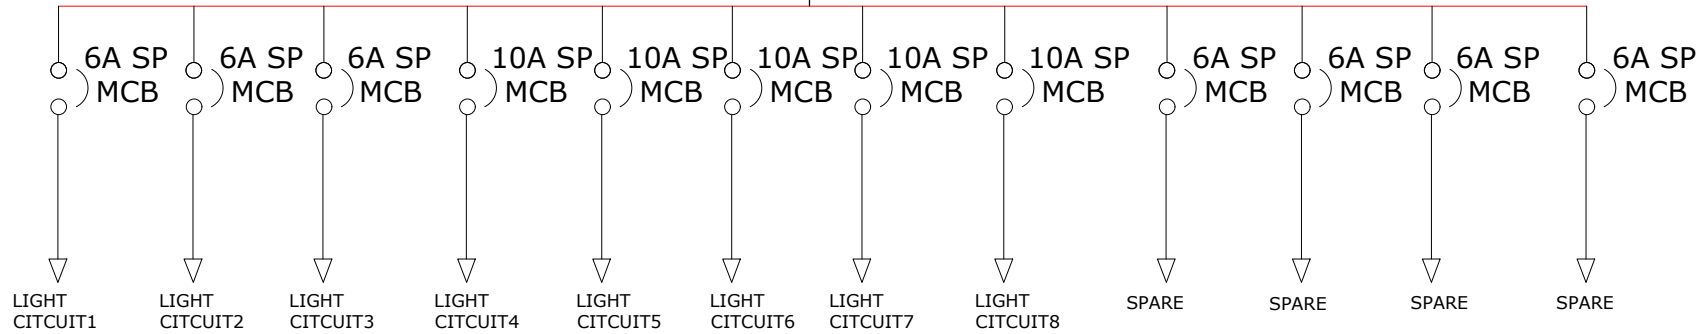

CANARA BANK KATTAKADA

MSB TO LIGHTING DB


Drawn by	SHANAVAS	
Architect	Ar.PRAVEEN.P B. Arch.[Reg], A.I.I.A, A.I.I.D	
Chief Architect	Ar. K. RAMAKRISHNAN B.Sc.(Engg), F.I.E, C. Eng (I), F.I.V , F.I.I.A. (Regd), A.I.I.D	
Date	: 14 - 12 - 2023	12 - 04 - 2024
Scale	: NTS	
Sheet No	: 02	
Note: All Dimensions are in CMs.		

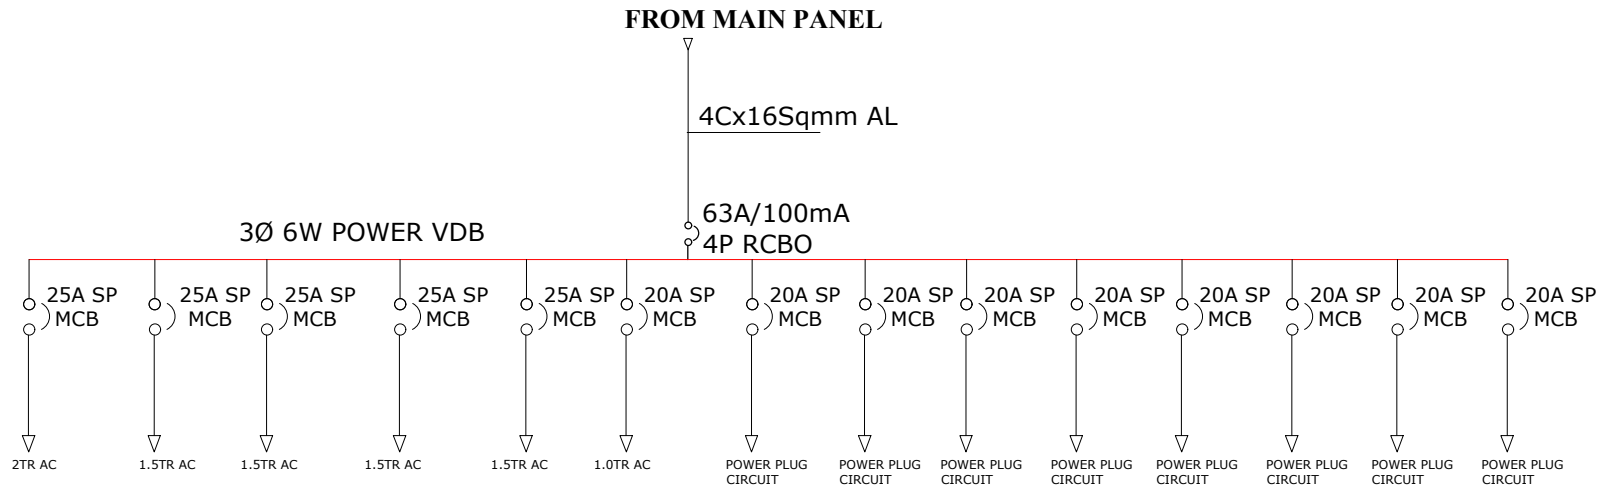

CANARA BANK KATTAKADA

MSB TO POWER DISTRIBUTION BOARD

Drawn by	SHANAVAS	
Architect	Ar.PRAVEEN.P B. Arch.[Reg], A.I.I.A, A.I.I.I.D	
Chief Architect	Ar. K. RAMAKRISHNAN B.Sc.(Engg), F.I.E, C. Eng (I), F.I.V , F.I.I.A. (Regd), A.I.I.I.D	
Date	: 14 - 12 - 2023	12 - 04 - 2024
Scale	: NTS	
Sheet No	: 03	
Note: All Dimensions are in CMs.		

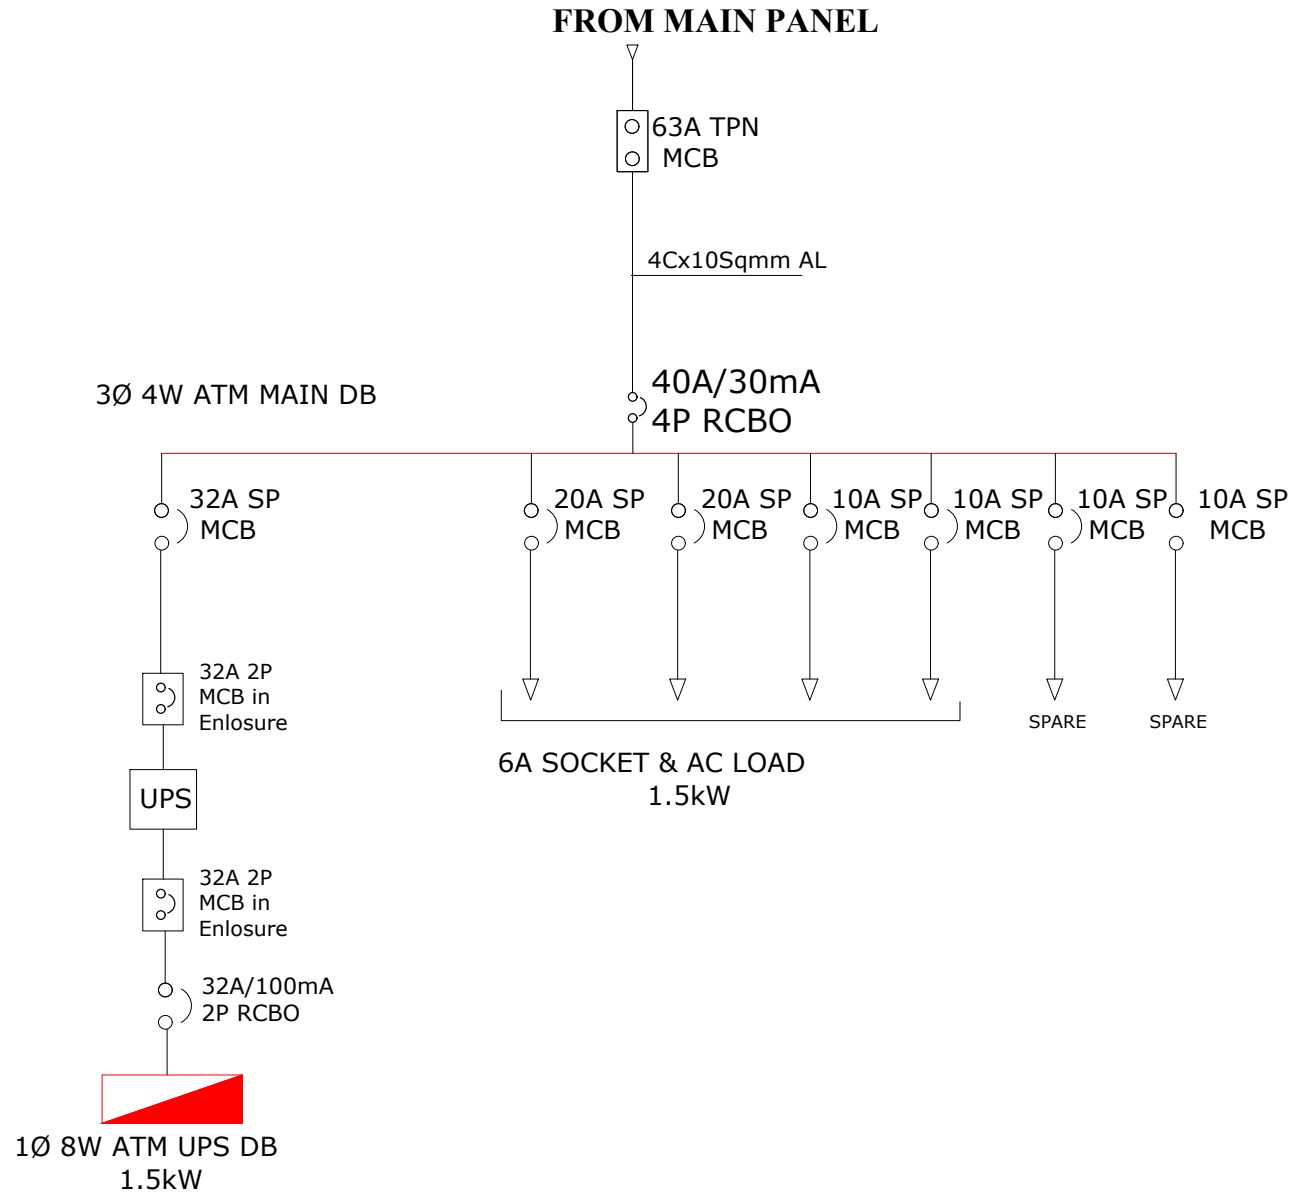

CANARA BANK KATTAKADA

MAIN PANEL TO ATM MAIN PANEL

Drawn by : SHANAVAS

Architect : Ar.PRAVEEN.P
B. Arch.[Reg], A.I.I.A, A.I.I.D

Chief Architect : Ar. K. RAMAKRISHNAN
B.Sc.(Engg), F.I.E, C. Eng (I),
F.I.V, F.I.I.A. (Regd), A.I.I.D

Date : 14 - 12 - 2023 12 - 04 - 2024

Scale : NTS

Sheet No : 04

Note: All Dimensions are in CMs.