


Slab -3.00M  
BEAM-2.63M

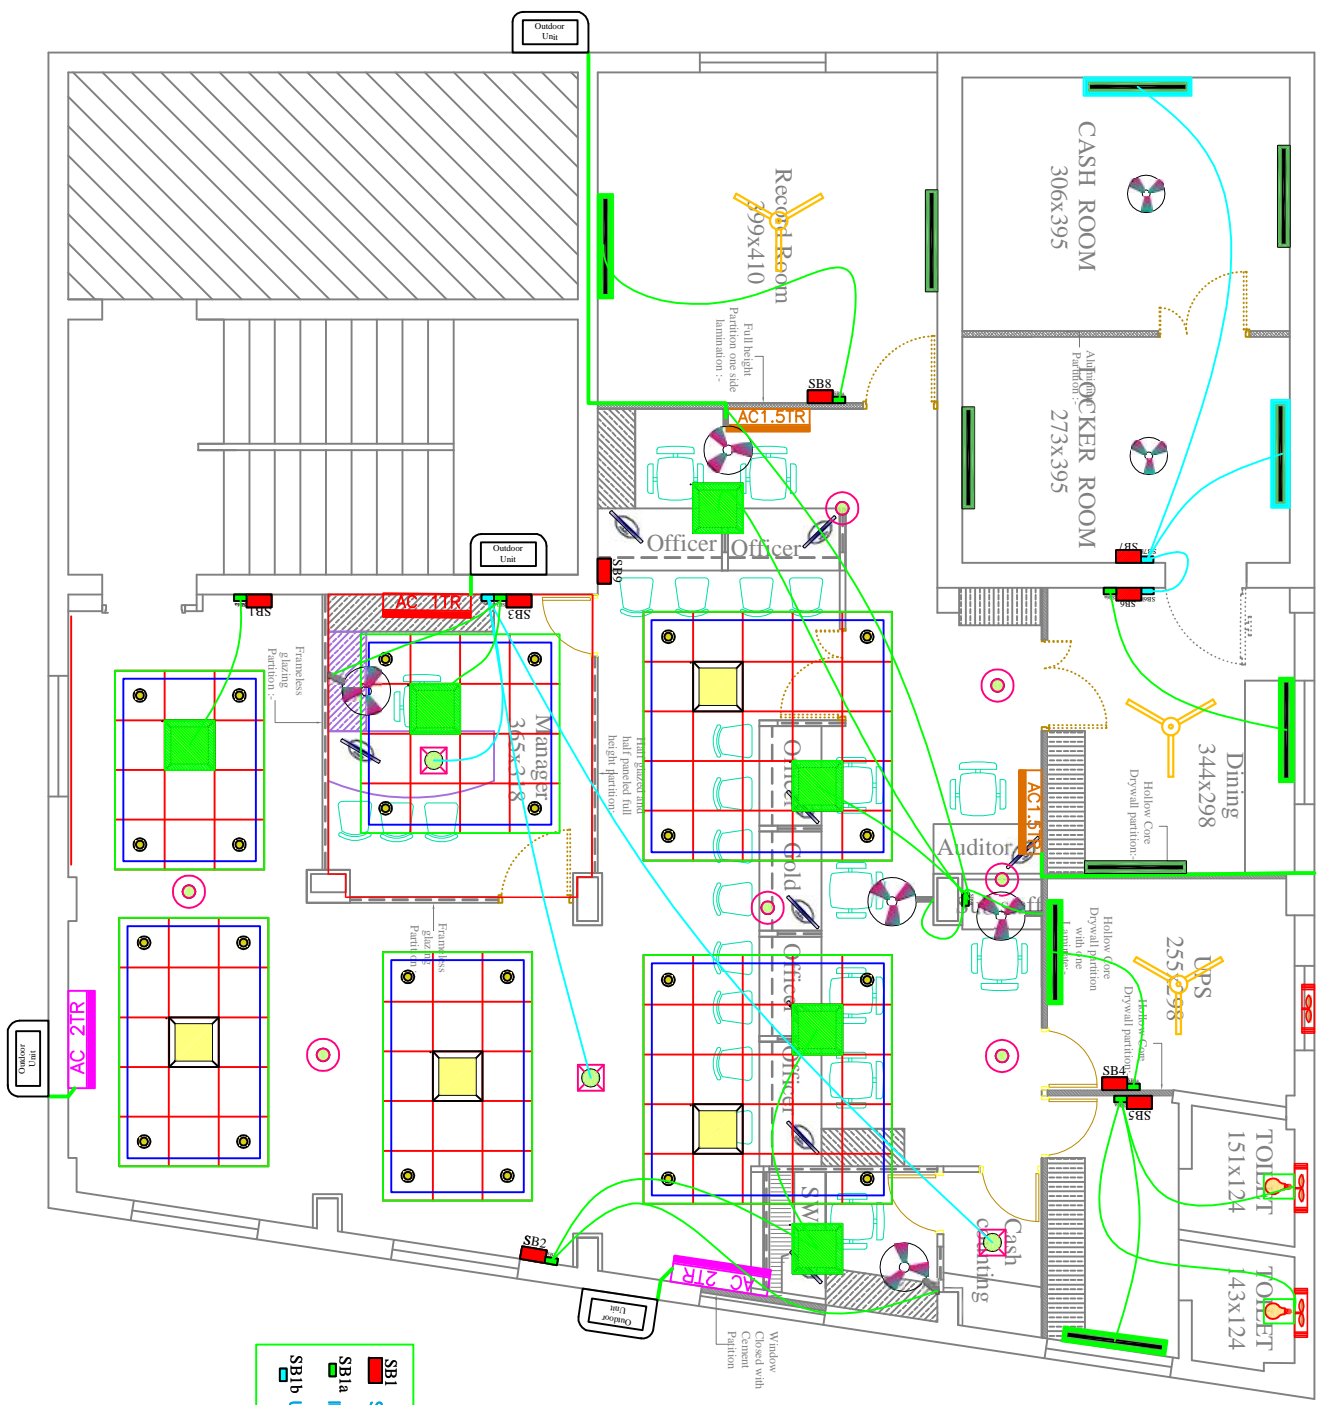

S.No	Rev	Date	Remarks	Sign	Check
1					

Symbol	Description	Quantity
●	1.5W ROUND LED FITTING	24
■	3.5W LED FITTING	8
■	3.5W LED FITTING FROM INVERTER	6
▲	LED Sub from INVERTER	2
■	LED TUBE FITTING	4
■	LED TUBE FITTING FROM INVERTER	4
■	LED TUBE FITTING FROM UPS	2
■	12" CHANSET FAN	3
■	1200MM CEILING FAN	3
○	1200MM CEILING FAN FROM INVERTER	0
○	COREN FAN	2
○	WALL FAN FROM INVERTER	5
○	STRIP LED	50M
○	1x18 ROUND FITTING	6
○	1x18 ROUND FITTING FROM INVERTER	0
○	1x18 ROUND FITTING FROM UPS	2
■	AC 21R	2
■	AC 31R	2
■	AC 41R	2
■	1.0TONE AC	1

Revisions

S.No	Rev	Date	Remarks	Sign	Check

Scale : NTS Date : 28-09-2023  
 DC : Suresh Detail :  
 Checked : Suresh Drawn By: Rohan  
 Drawing No : 2 Job no :  
 ALL DIMENSIONS ARE IN CENTIMETERS

Title : CANARA BANK KATTAPPANA  
 Name of work :  
 INVERTER & UPS LIGHTING LAYOUT

Clients Signature-  
 Client :  
 Canara Bank  
 Regional Office  
 Kottayam

Architects Signature & seal :-  
 Architect :  
*Prima-shah*

Head office  
 (Architect, CA-84 8733 REG Value-F-3047)  
 359 - E, 1st Floor  
 Convent Road, Cherthala - 688 524  
 PH - 0478 - 2820159  
 E-mail primaarch@gmail.com